




WAIMAKARIRI
DISTRICT COUNCIL

215 High Street, RANGIORA
Tel. 03 313 6136
Fax. 03 313 4432

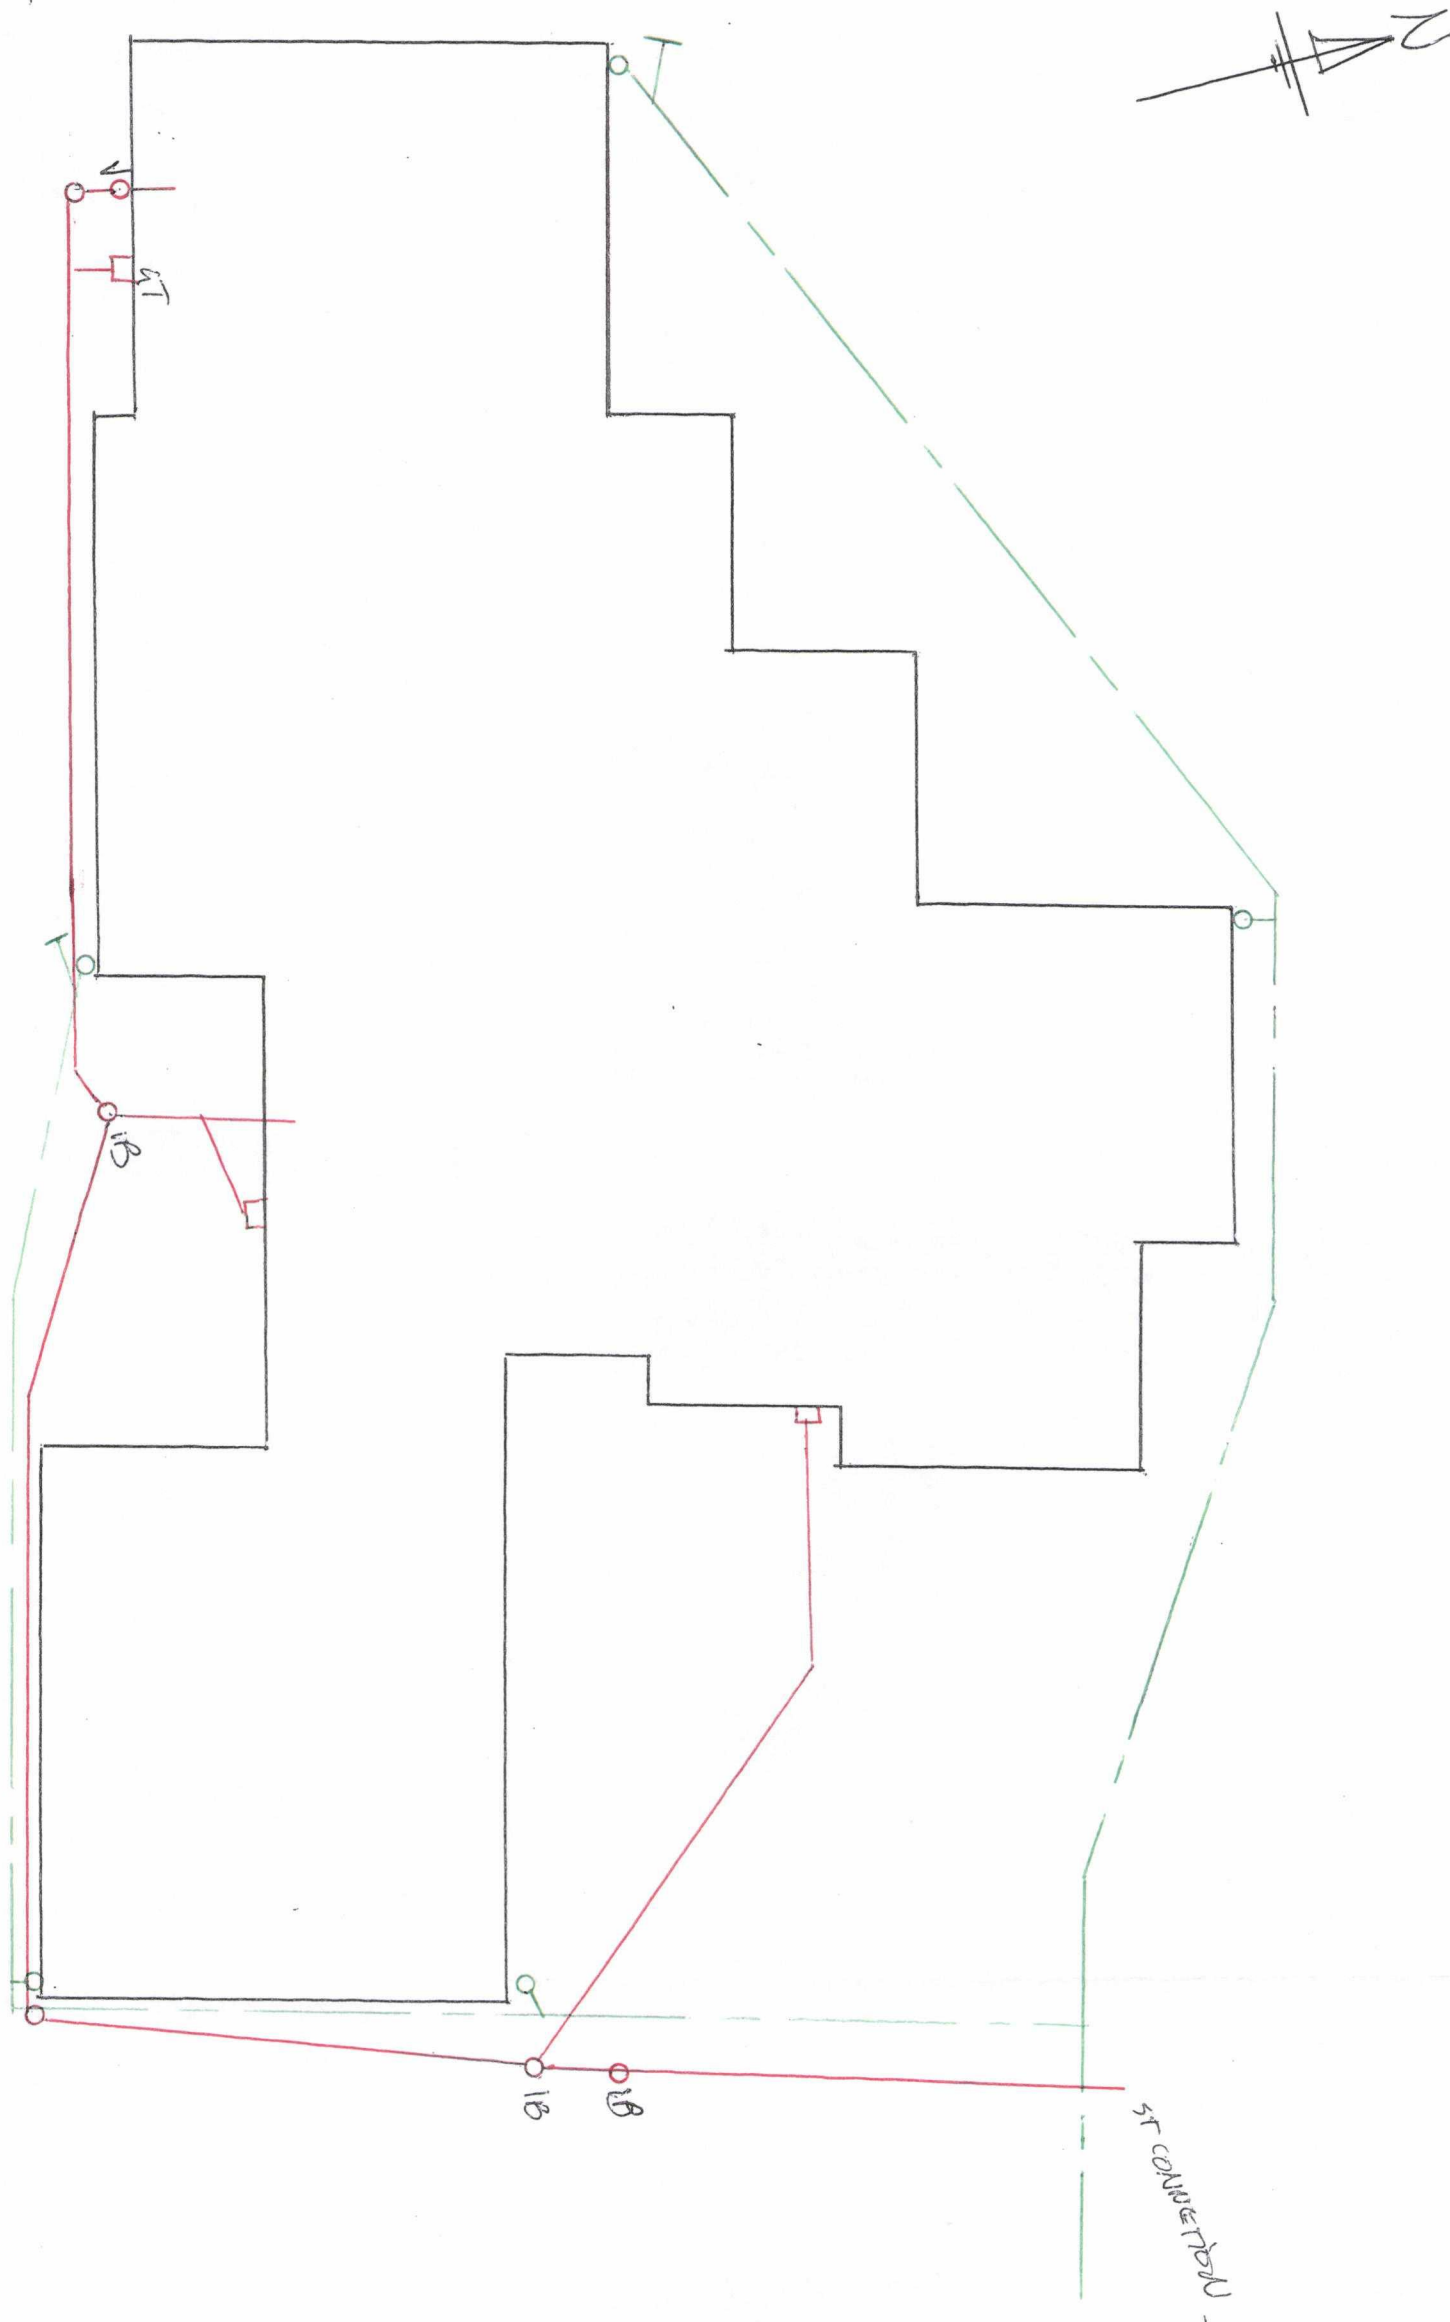

		LEGEND: SEWER ——— STORMWATER ———	DRAINAGE PLAN
SCALE: 1:100		DRAWN BY: L. MILLER.	
NAME: HENDRICKUS & LELAH KOBUSEN.			JOB N°:
ADDRESS: 32 ALLIANCE CRESENT, KAIA 'OI			VAL N°:
DRAINLAYER:			INSPECTED:
			DATE DRAWN: 19/1/06.