


Wanganui District Council
- 2 MAR 2007
RECEIVED

Wanganui District Council
- 2 MAR 2007
RECEIVED

APPROVED
07 / 0244
Consent No.

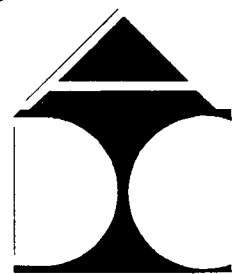


Architectural
Draughting
Centre


Herman de Jonge

54 Holmwood Road, Kaitoke, RD 2, Wanganui
Ph/Fax 06 347 1994 Mobile 021 285 7233
hdejonge@xtra.co.nz Copyright 2000 : ADC

**NEW HOUSES FOR BASELINE CONSTRUCTION,
151 GREAT NORTH ROAD, WANGANUI**

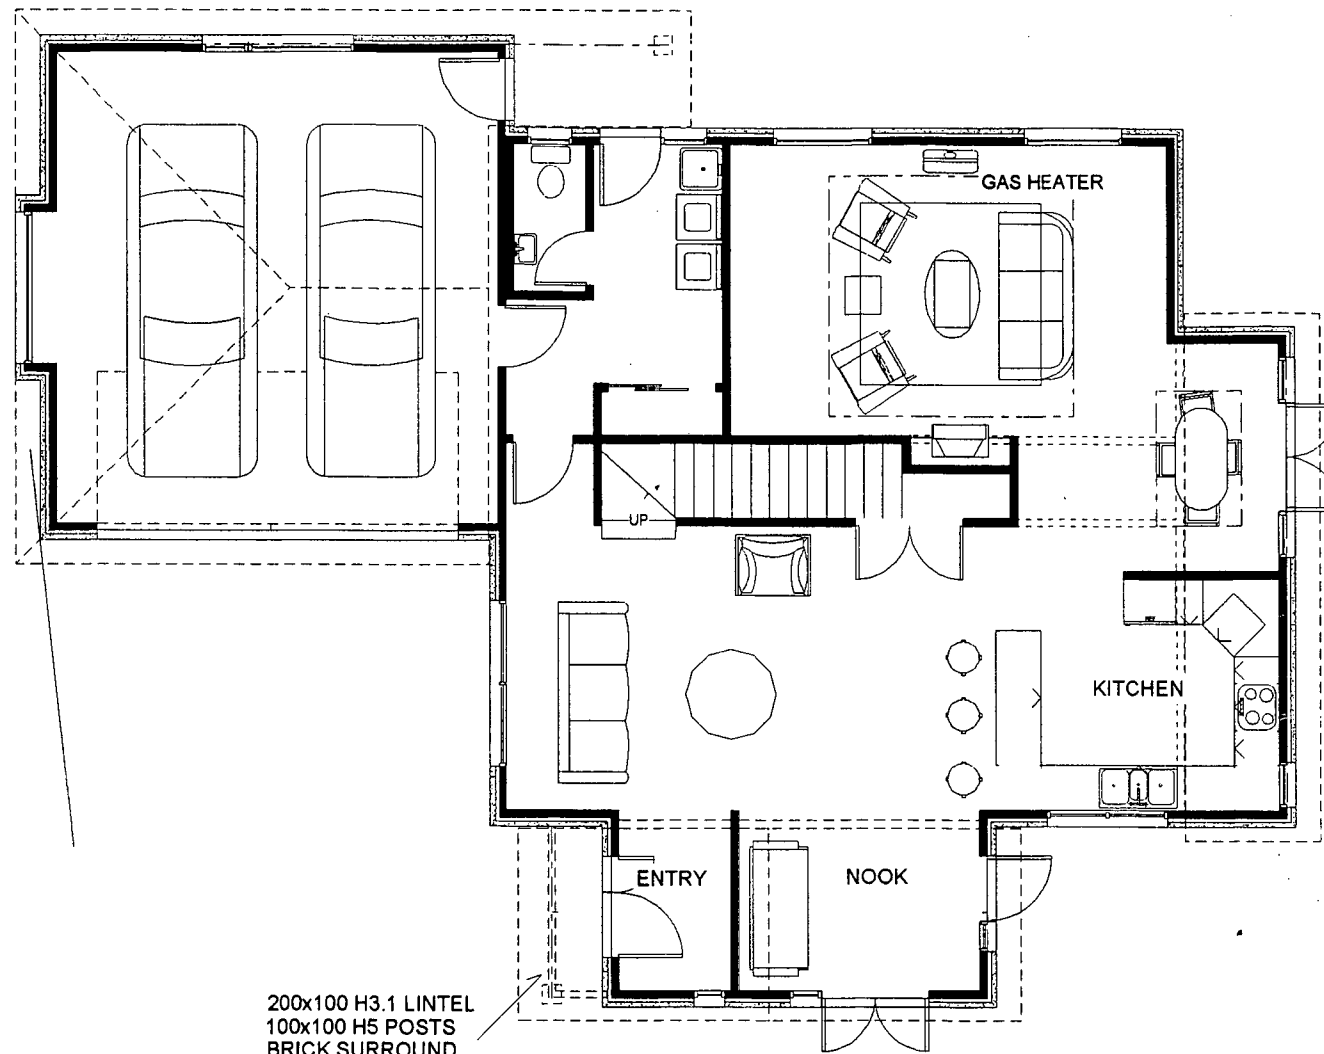

GROUND FLOOR PLAN
SCALE 1:100

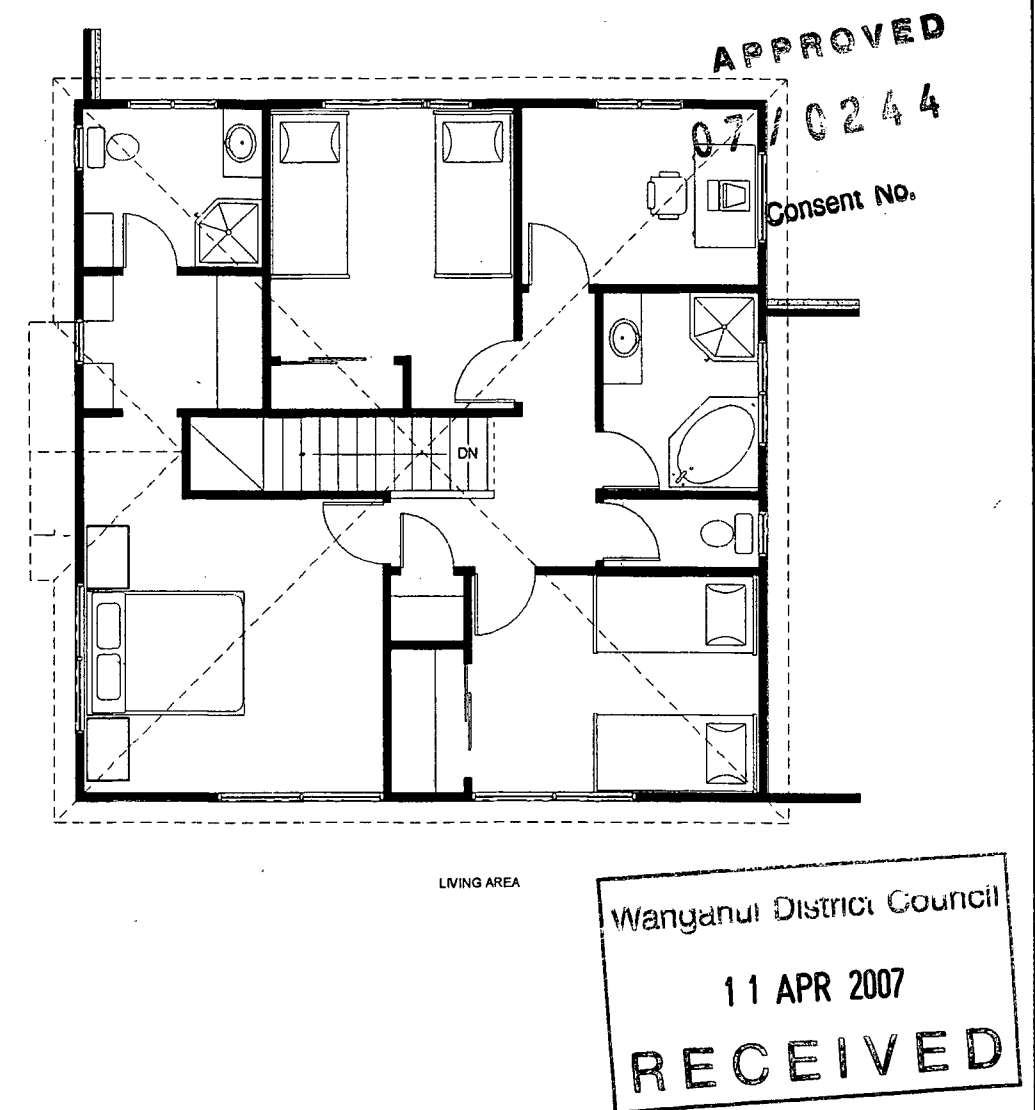

UPPER FLOOR PLAN
SCALE 1:100



Architectural
Draughting
Centre

Herman de Jonge


54 Holmwood Road, Kaitoke, RD 2, Wanganui
Ph/Fax 06 347 1994 Mobile 021 285 7233
hdejonge@xtra.co.nz Copyright 2000 : ADC


BASELINE CONSTRUCTION, 151 GREAT NORTH RD, WANGANUI

HOUSE A

REV A: 10-4-07
23 FEBRUARY 07

1

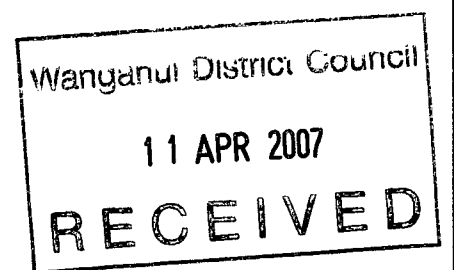

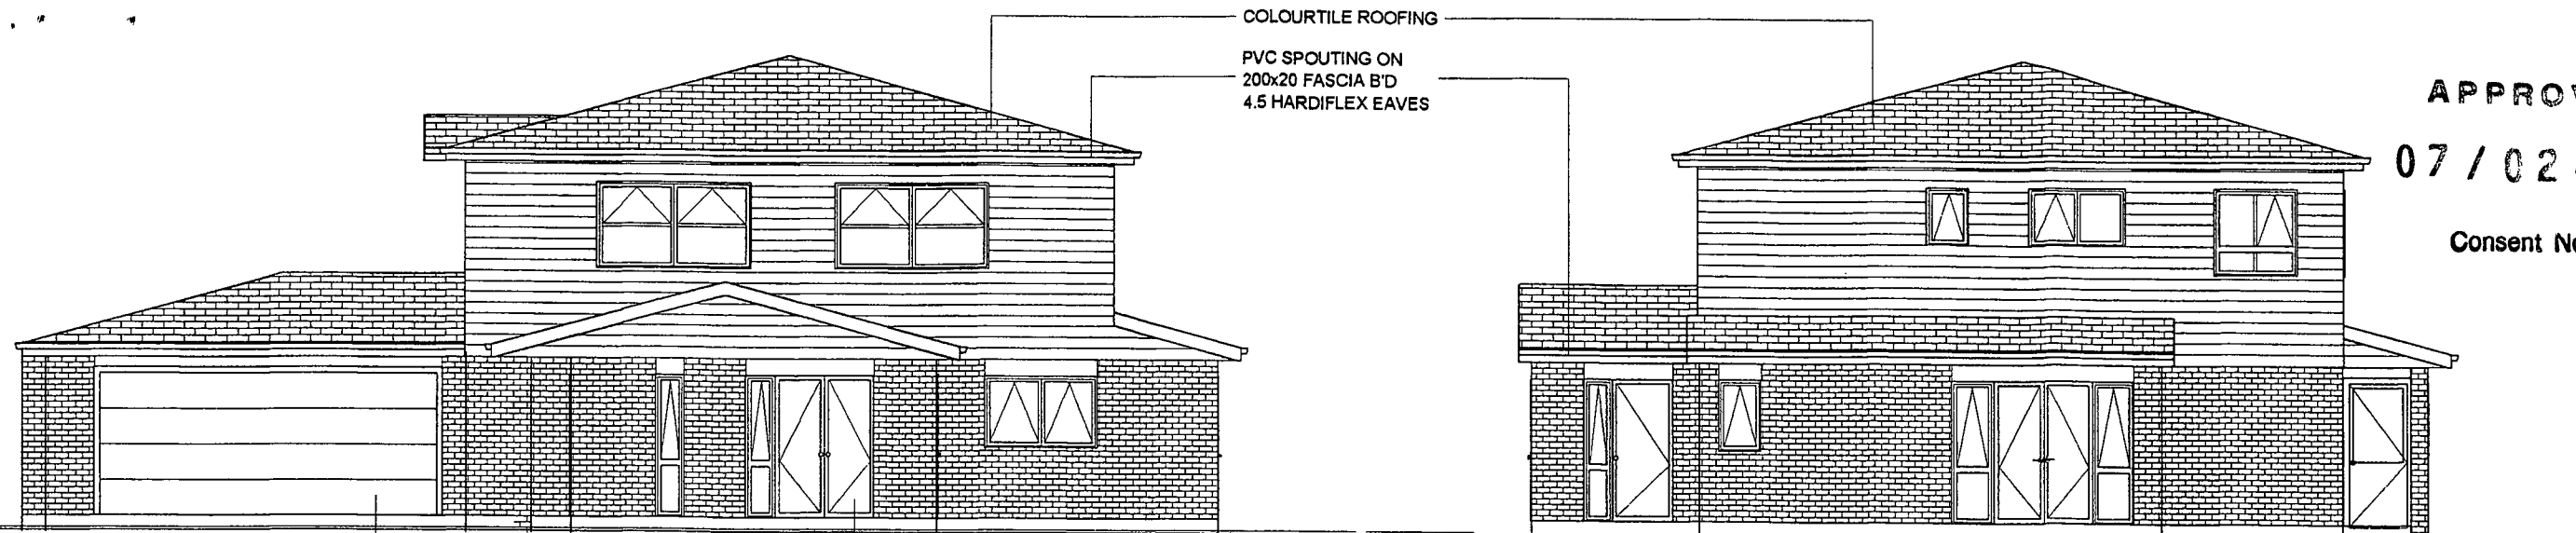

NORTH WEST

SOUTH WEST


APPROVED

07 / 02 44

Consent No.

RISK MATRIX ALL ELEVATIONS		
WIND ZONE	MEDIUM	0
NUMBER OF STOREYS	HIGH	2
ROOF/WALL INTERSECTION	LOW	0
EAVES WIDTH	VERY HIGH	5
ENVELOPE COMPLEXITY	MEDIUM	1
DECK DESIGN	LOW	0
TOTAL SCORE		8

11 APR 2007
RECEIVED

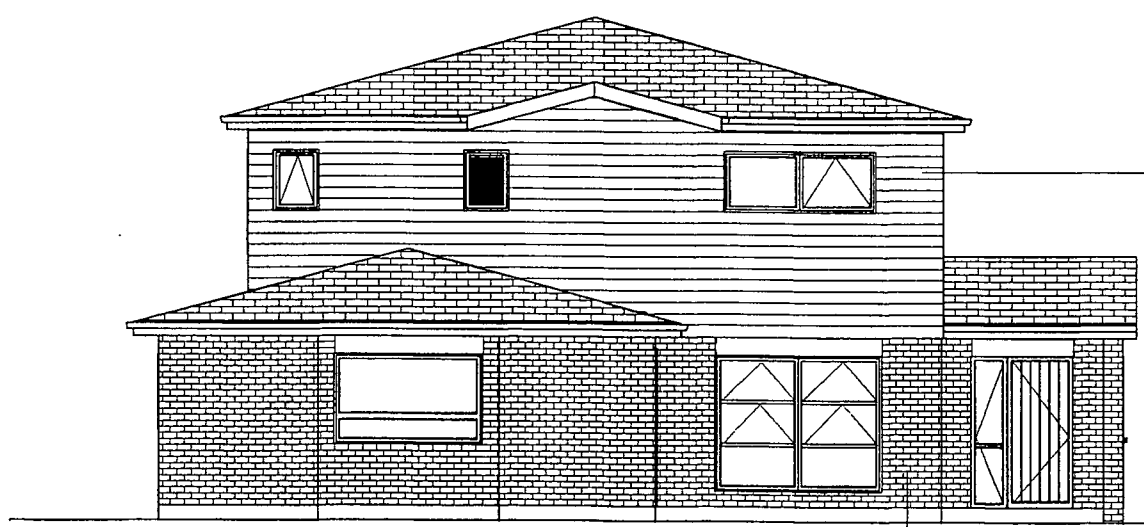

NORTH EAST



SOUTH EAST


**Architectural
Draughting
Centre**
Herman de Jonge
 54 Holmwood Road, Kaitoke, RD 2, Wanganui
 Ph/Fax 06 347 1994 Mobile 021 285 7233
 hdejonge@xtra.co.nz Copyright 2000 : ADC

ELEVATIONS
SCALE 1:100

HOUSE A

BASELINE CONSTRUCTION, 151 GREAT NORTH RD, WANGANUI

REV A: 10-4-07
23 FEBRUARY 07

2

SET OUT PLANS


SCALE 1:100

Wanganui District Council


- 2 MAR 2007

RECEIVED

Consent No.

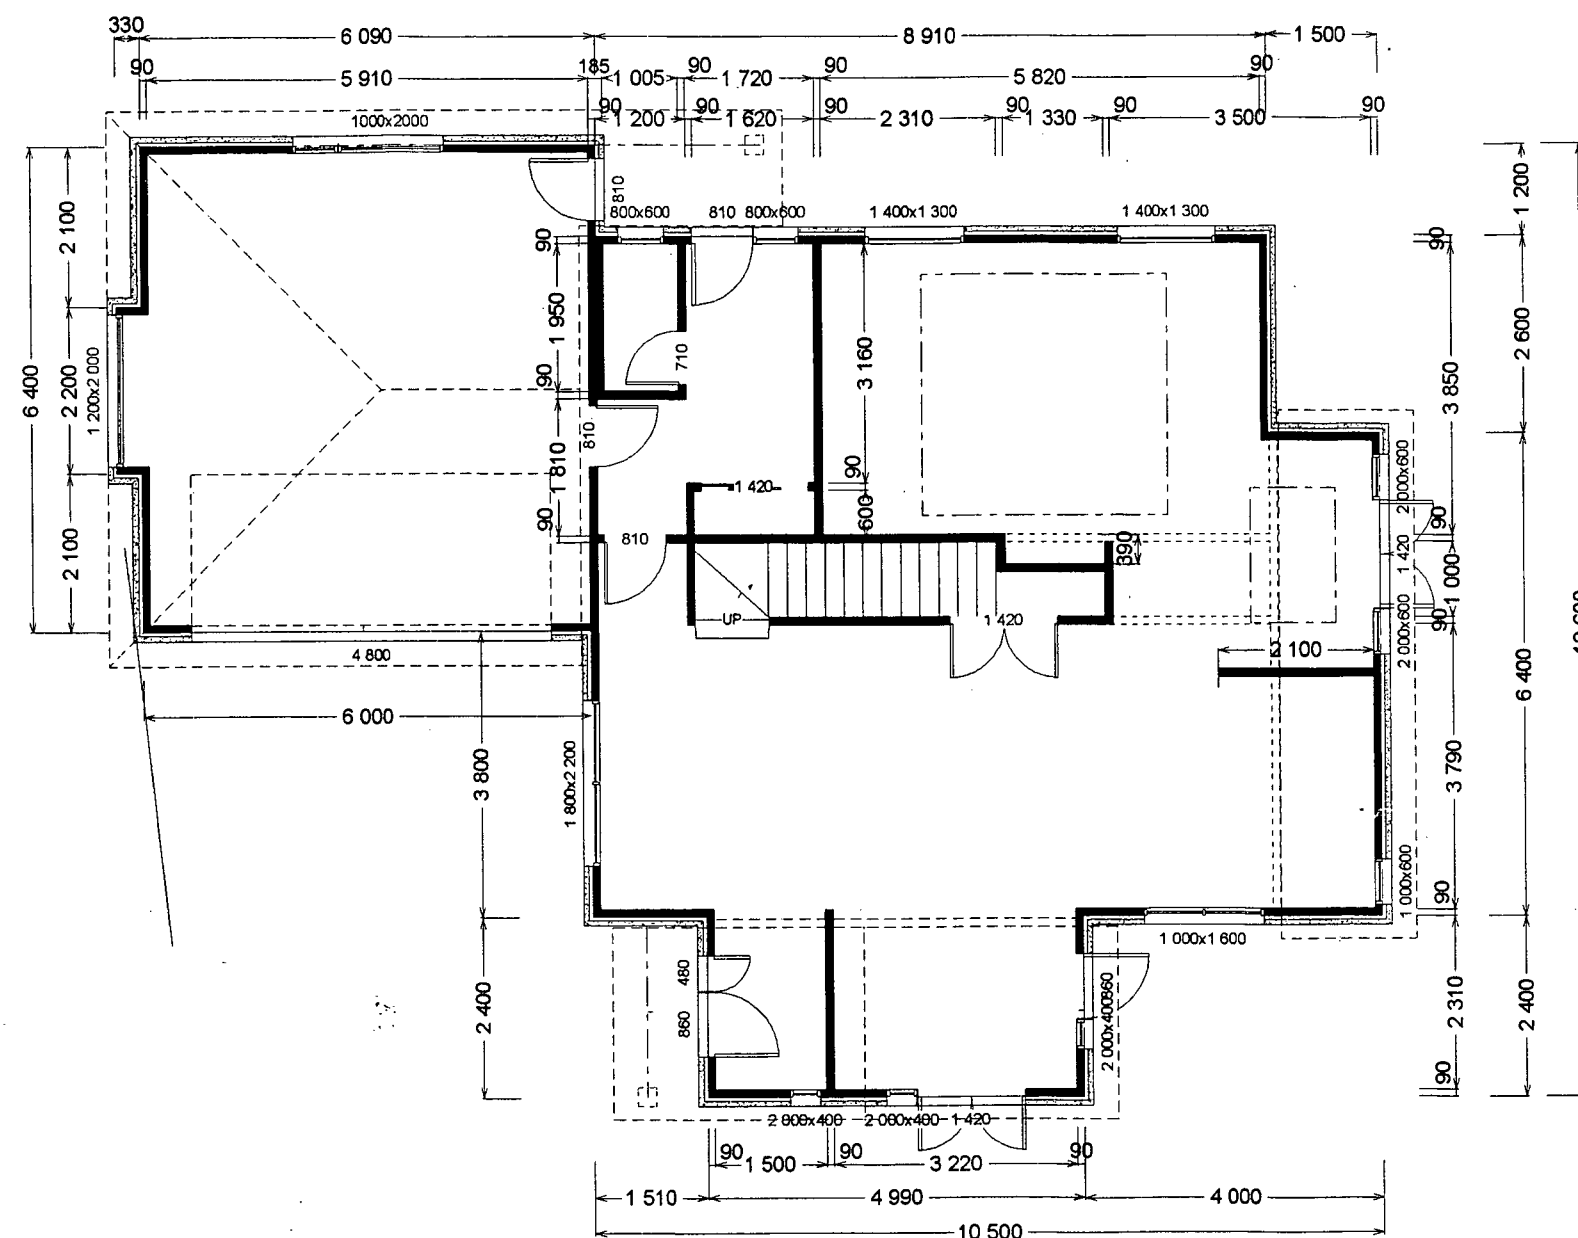

GROUND FLOOR

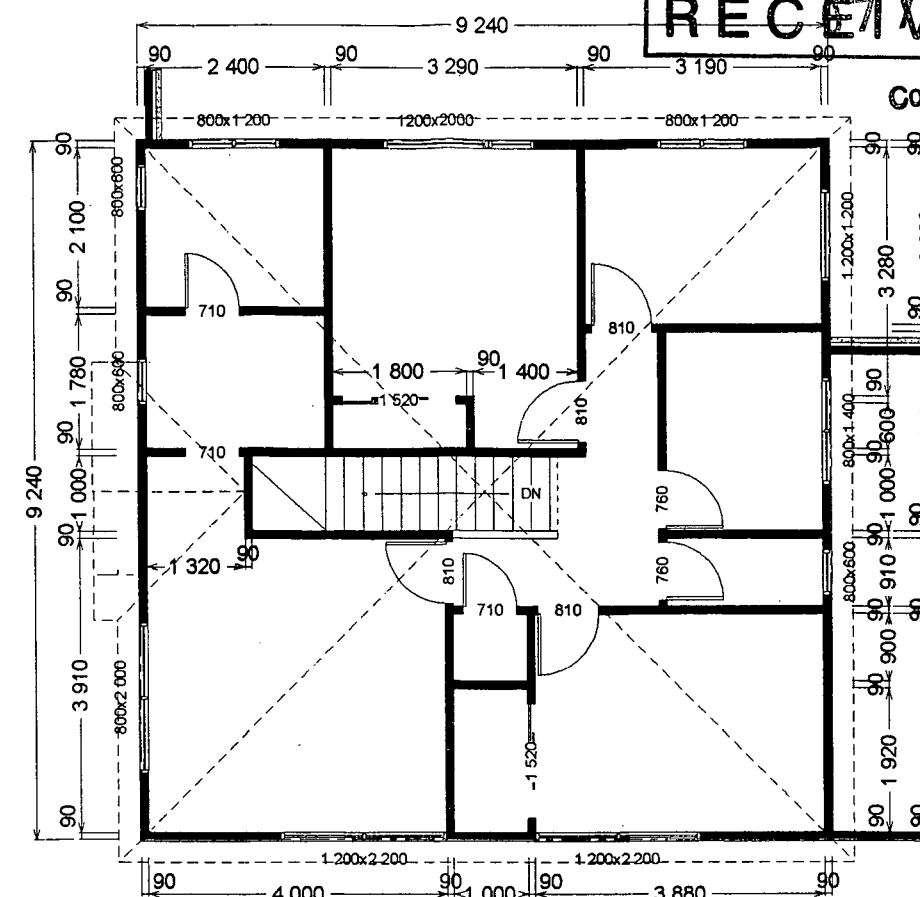

UPPER FLOOR

HOUSE A

BASELINE CONSTRUCTION, 151 GREAT NORTH RD, WANGANUI



Architectural
Draughting
Centre

Herman de Jonge

54 Holmwood Road, Kaitoke, RD 2, Wanganui
Ph/Fax 06 347 1994 Mobile 021 285 7233
hdejonge@xtra.co.nz Copyright 2000 : ADC

23 FEBRUARY 07

3

Wanganui District Council

-2 MAR 2007


RECEIVED

07/02/07

Consent No.

240x45 H1.2 JOISTS
@ 450 CRS

240x90 H1.2 LINTELS

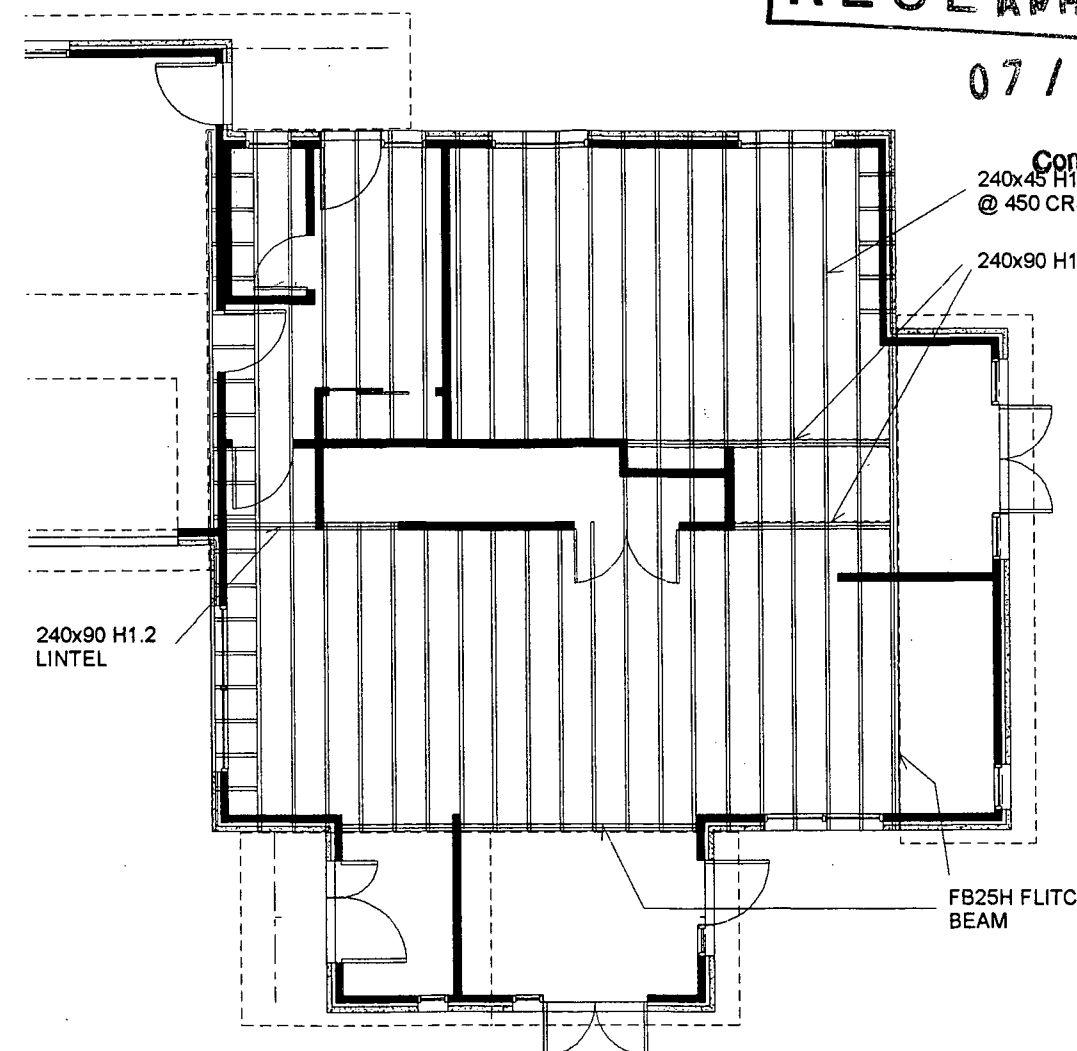


UPPER FLOOR
FRAMING PLAN

SCALE 1:100

FOUNDATION PLAN

SCALE 1:100

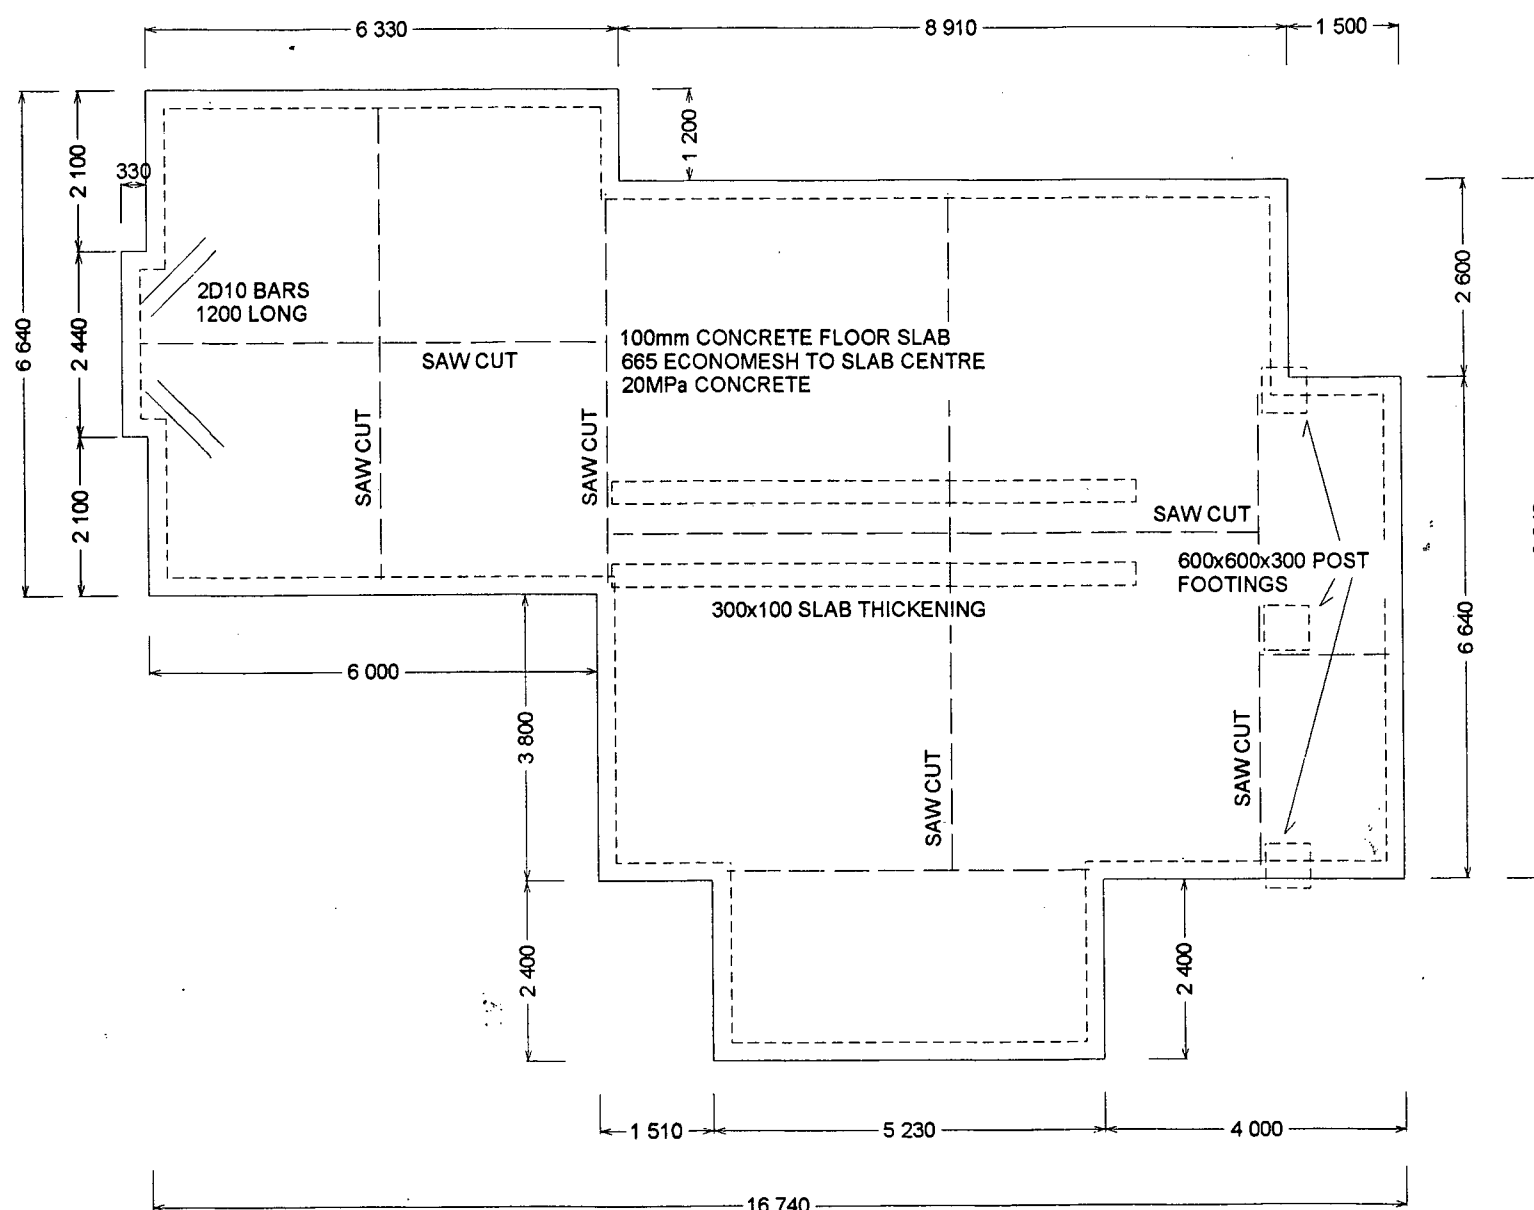

Architectural
Draughting
Centre

Herman de Jonge


54 Holmwood Road, Kaitoke, RD 2, Wanganui
Ph/Fax 06 347 1994 Mobile 021 285 7233
hdejonge@xtra.co.nz Copyright 2000 : ADC

BASELINE CONSTRUCTION, 151 GREAT NORTH RD, WANGANUI

23 FEBRUARY 07

4

HOUSE A

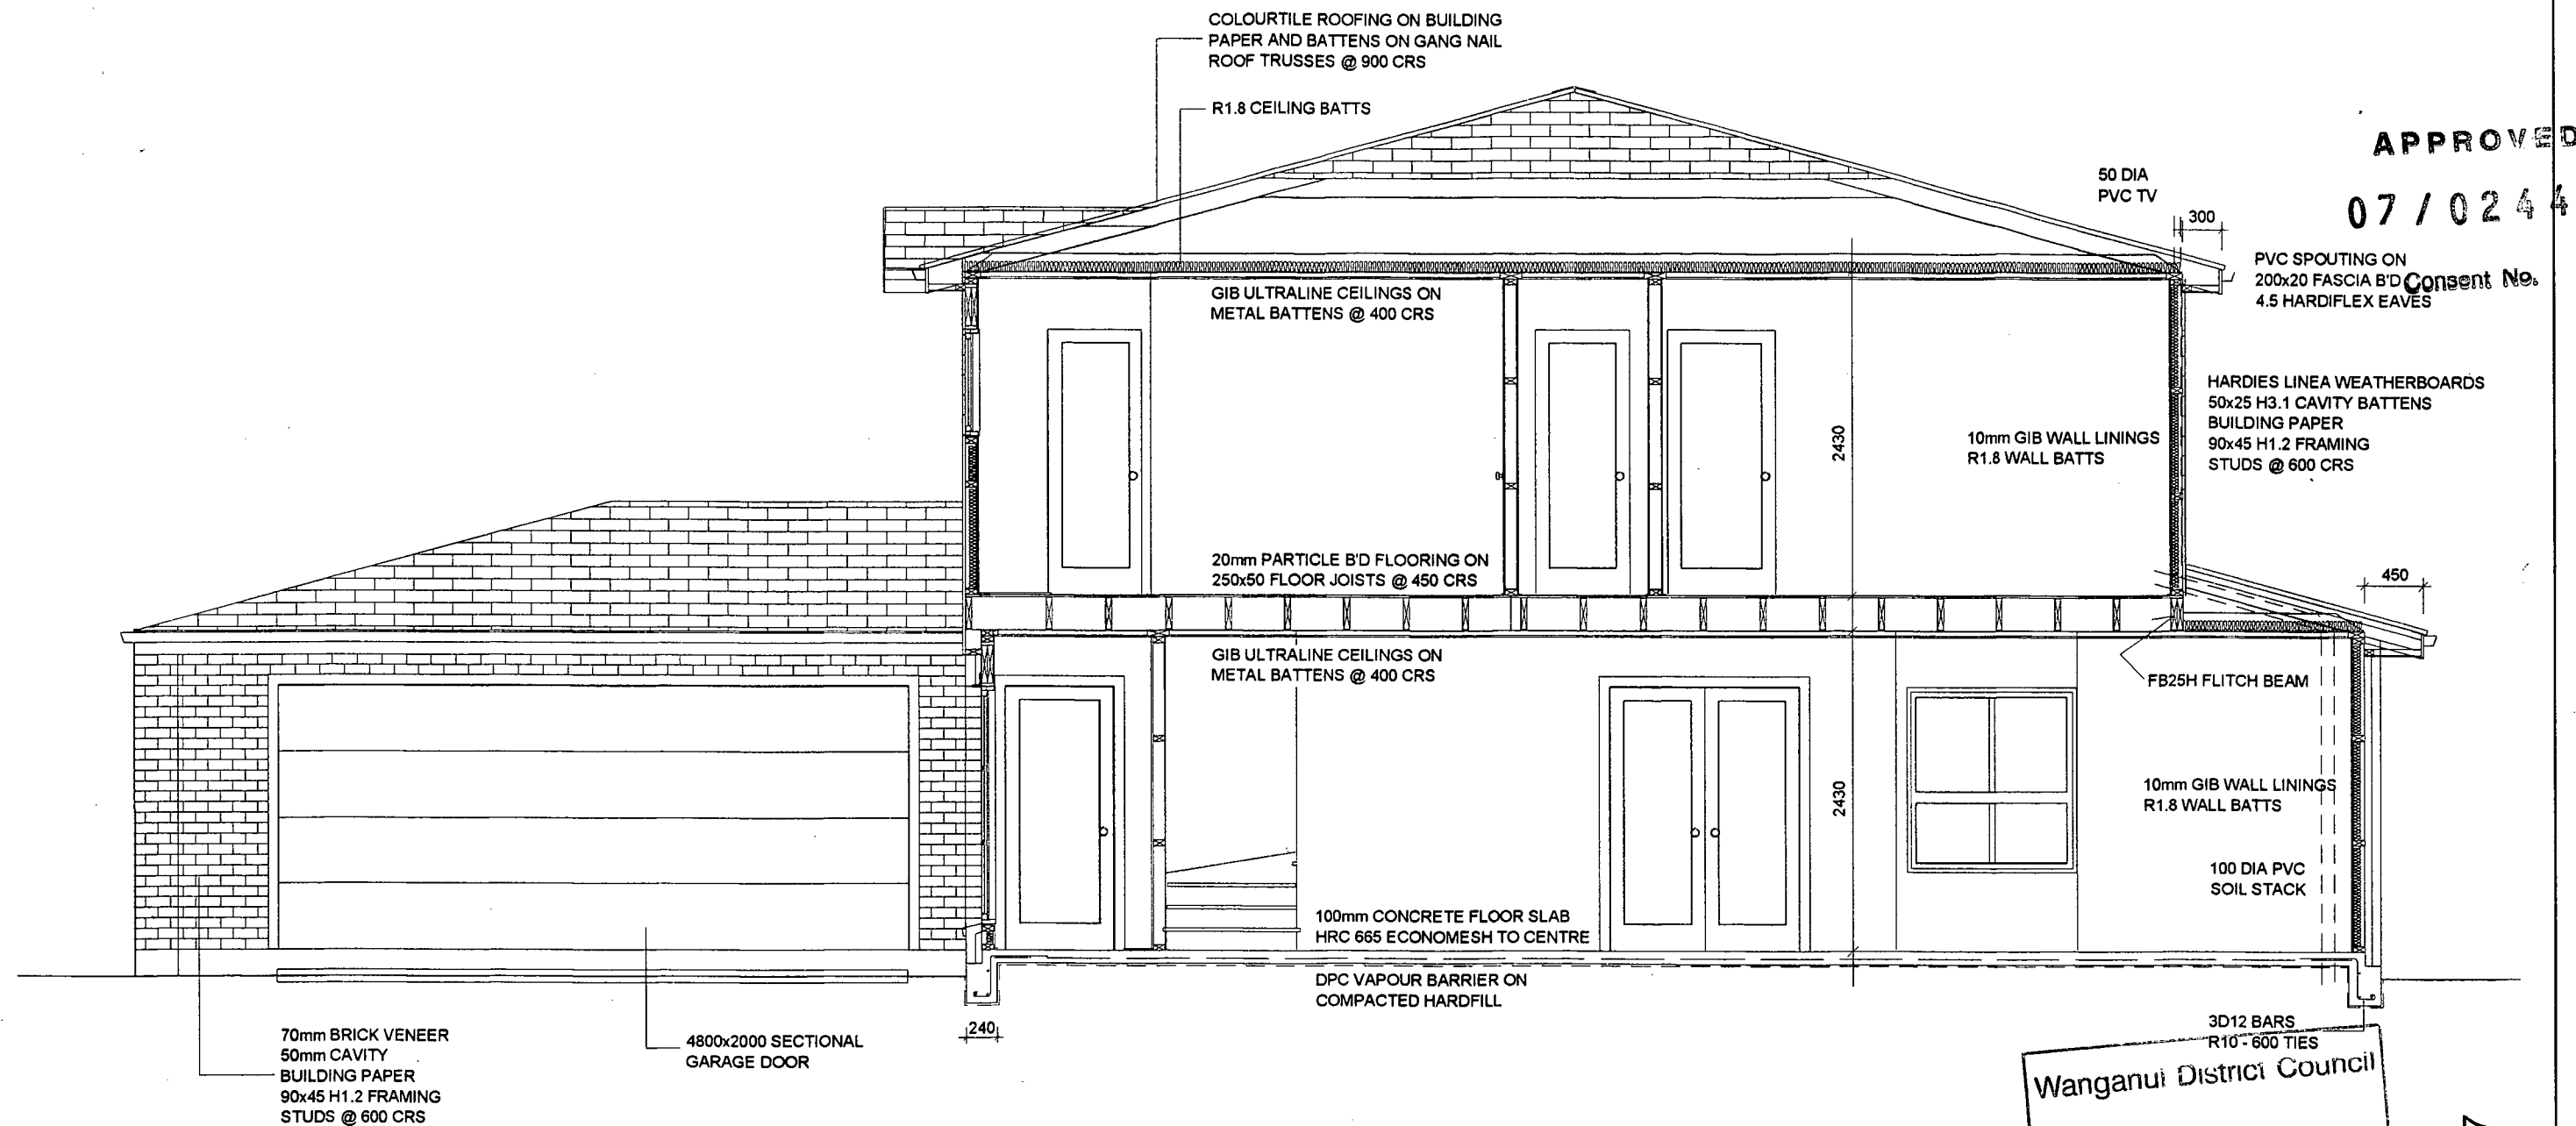

CROSS SECTION HOUSE A
HOUSE B SIMILAR

SCALE 1:50

Wanganui District Council
11 APR 2007
RECEIVED

REV A: 10-4-07
23 FEBRUARY 07

HOUSE A & B



 
Architectural
Draughting
Centre

Herman de Jonge

54 Holmwood Road, Kaitoke, RD 2, Wanganui
Ph/Fax 06 347 1994 Mobile 021 285 7233
hdejonge@xtra.co.nz Copyright 2000 : ADC

BASELINE CONSTRUCTION, 151 GREAT NORTH RD, WANGANUI

5



6

BASELINE CONSTRUCTION, 151 GREAT NORTH RD, WANGANUI

ELECTRICAL PLANS

SCALE 1:100


Wanganui District Council

-2 MAR 2007

RECEIVED

07/0244


Consent No.

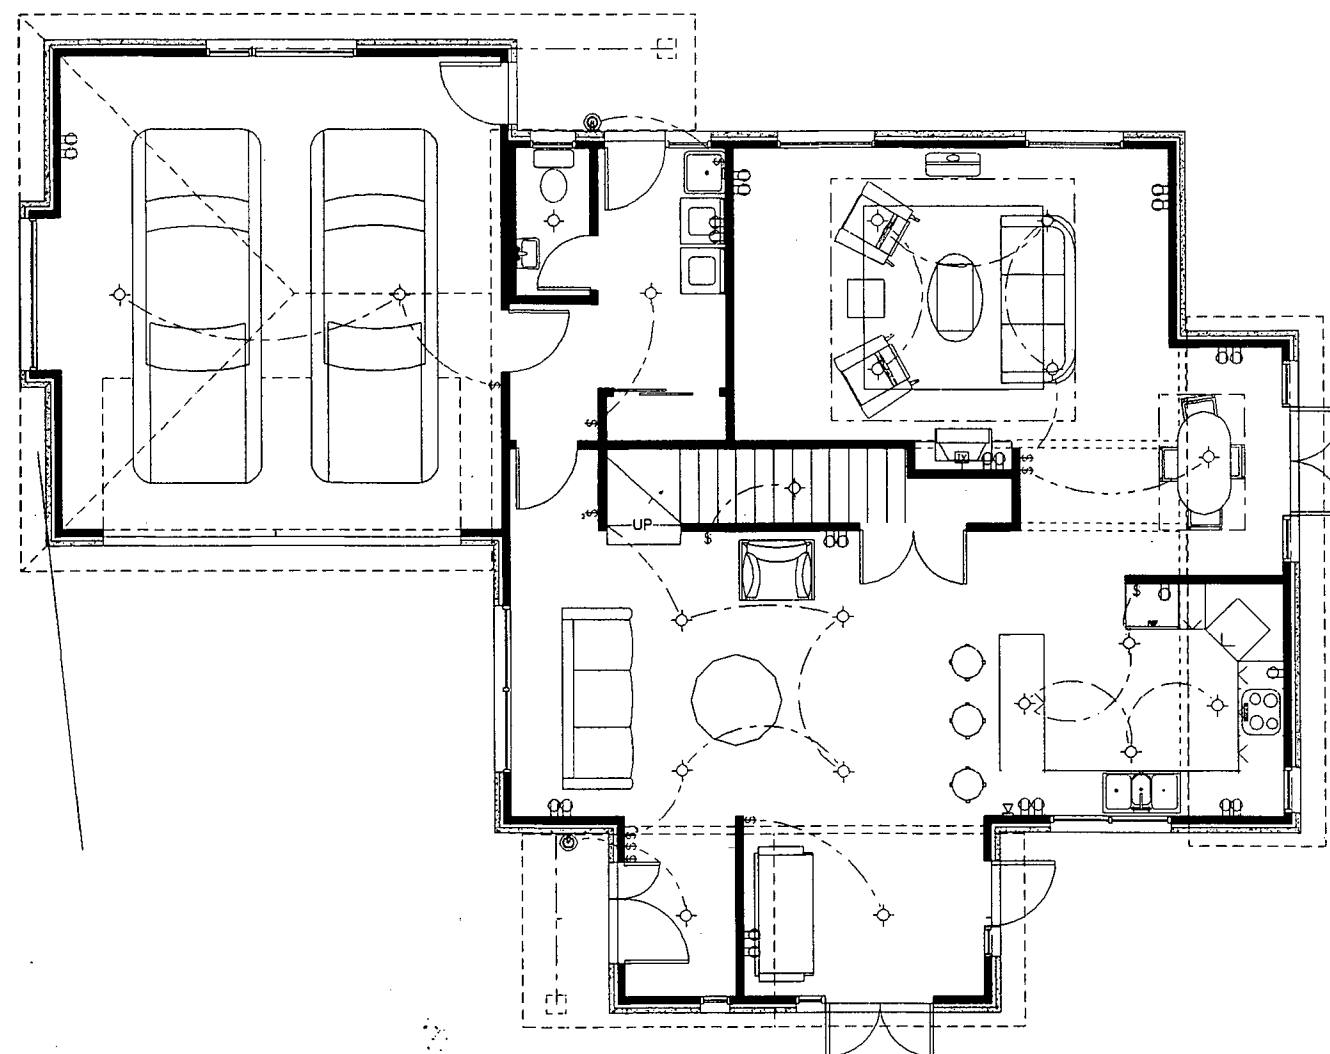

GROUND FLOOR

ELECTRICAL LEGEND

	CEILING LIGHTS	
	TELEPHONE	
	TELEVISION	
	POWERPOINT	
	SMOKE DETECTOR	
	LIGHT SWITCH	
	ELECTRICAL CONNECTION	

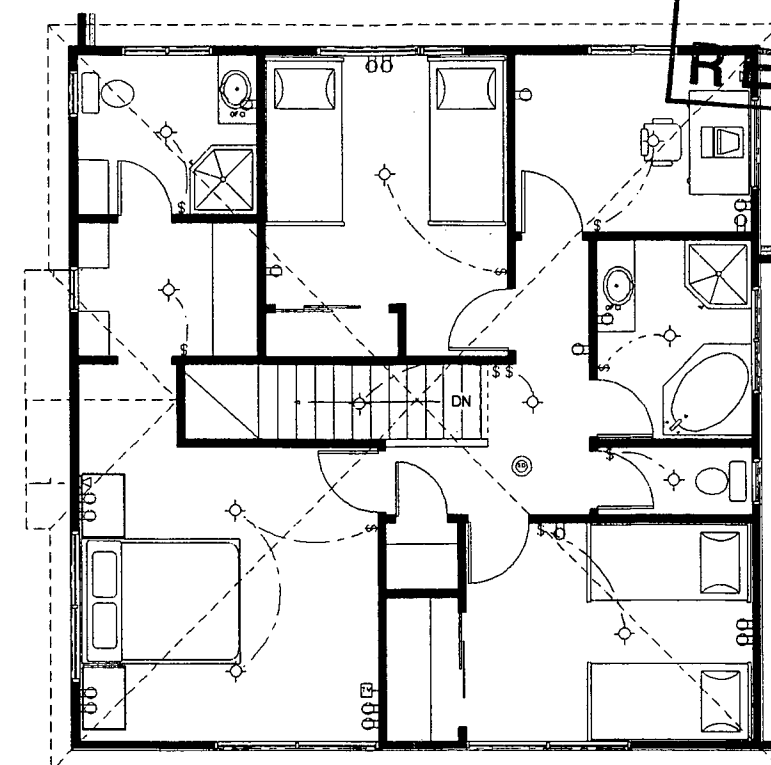

UPPER FLOOR

HOUSE A



Architectural
Draughting
Centre

Herman de Jonge

54 Holmwood Road, Kaitoke, RD 2, Wanganui
Ph/Fax 06 347 1994 Mobile 021 285 7233
hdejonge@xtra.co.nz Copyright 2000 : ADC

BASELINE CONSTRUCTION, 151 GREAT NORTH RD, WANGANUI

23 FEBRUARY 07


7

BRACING PLANS

SCALE 1:100


Wanganui District Council
O -2 MAR 2007
RECEIVED
07/02/07

Consent No.

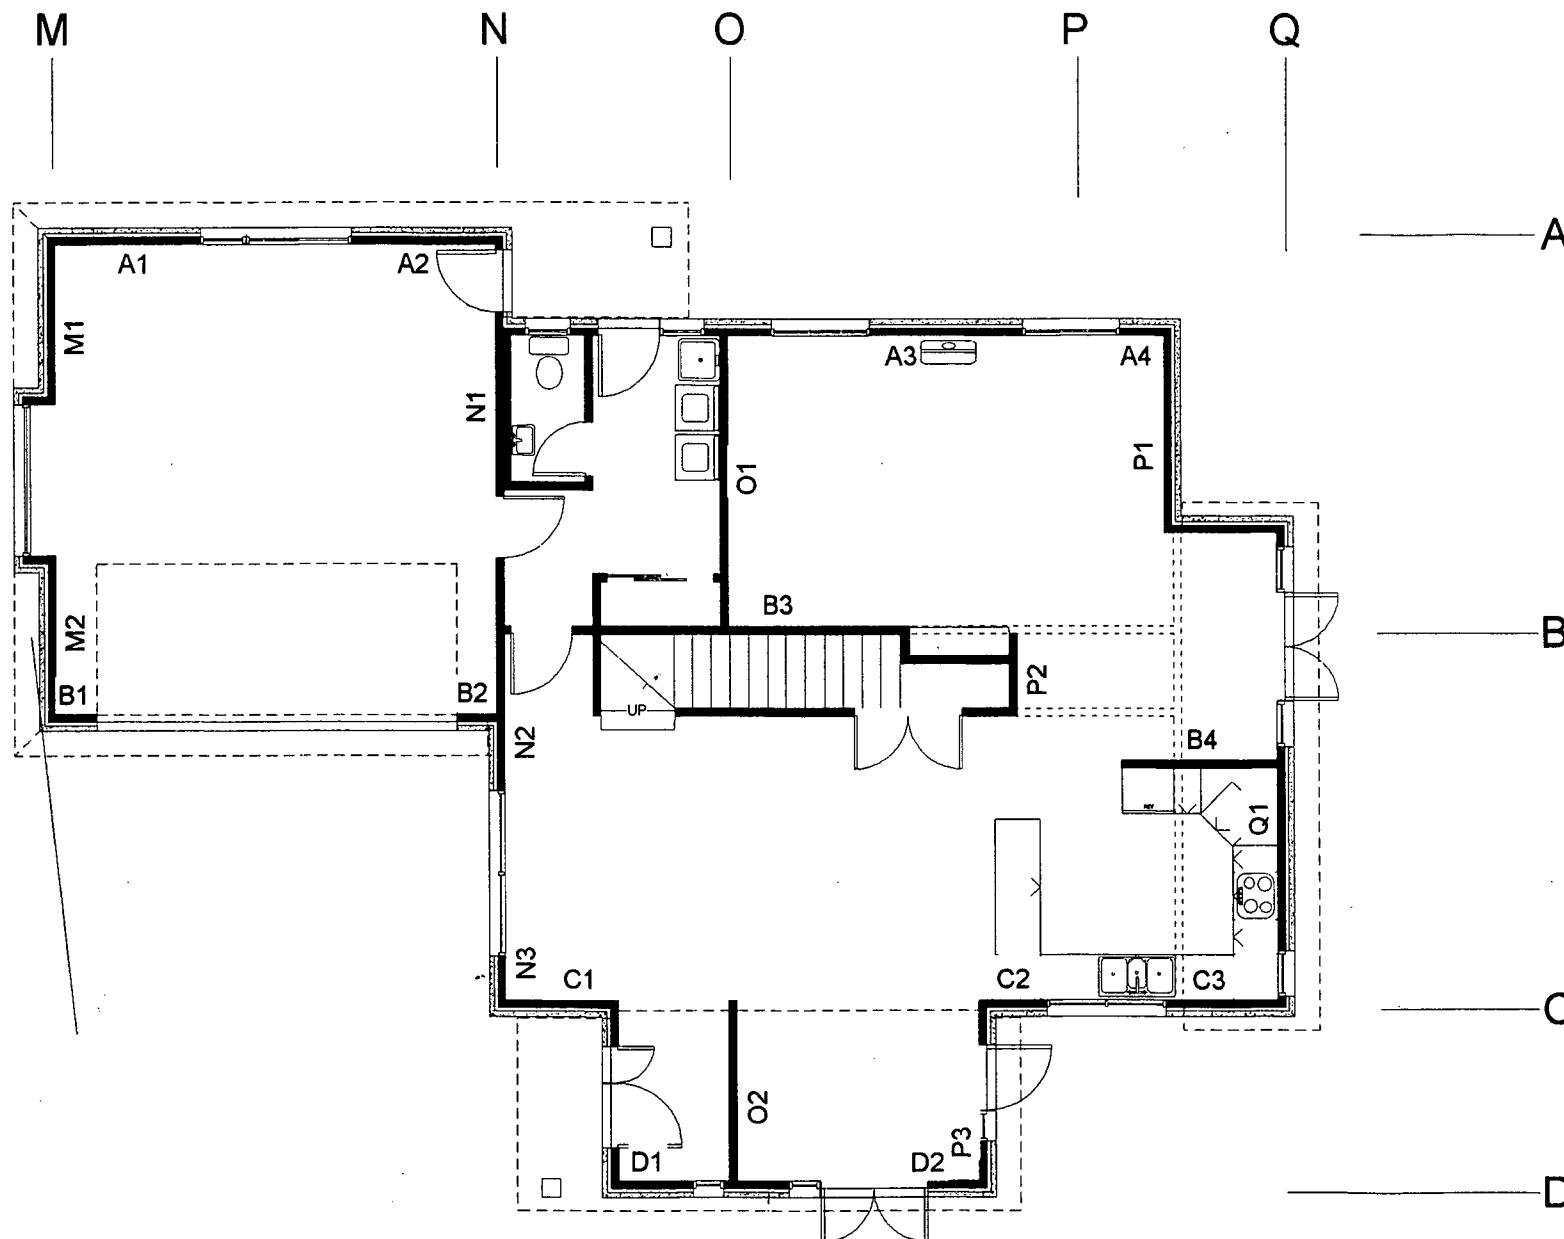

GROUND FLOOR

AREA 150 m2

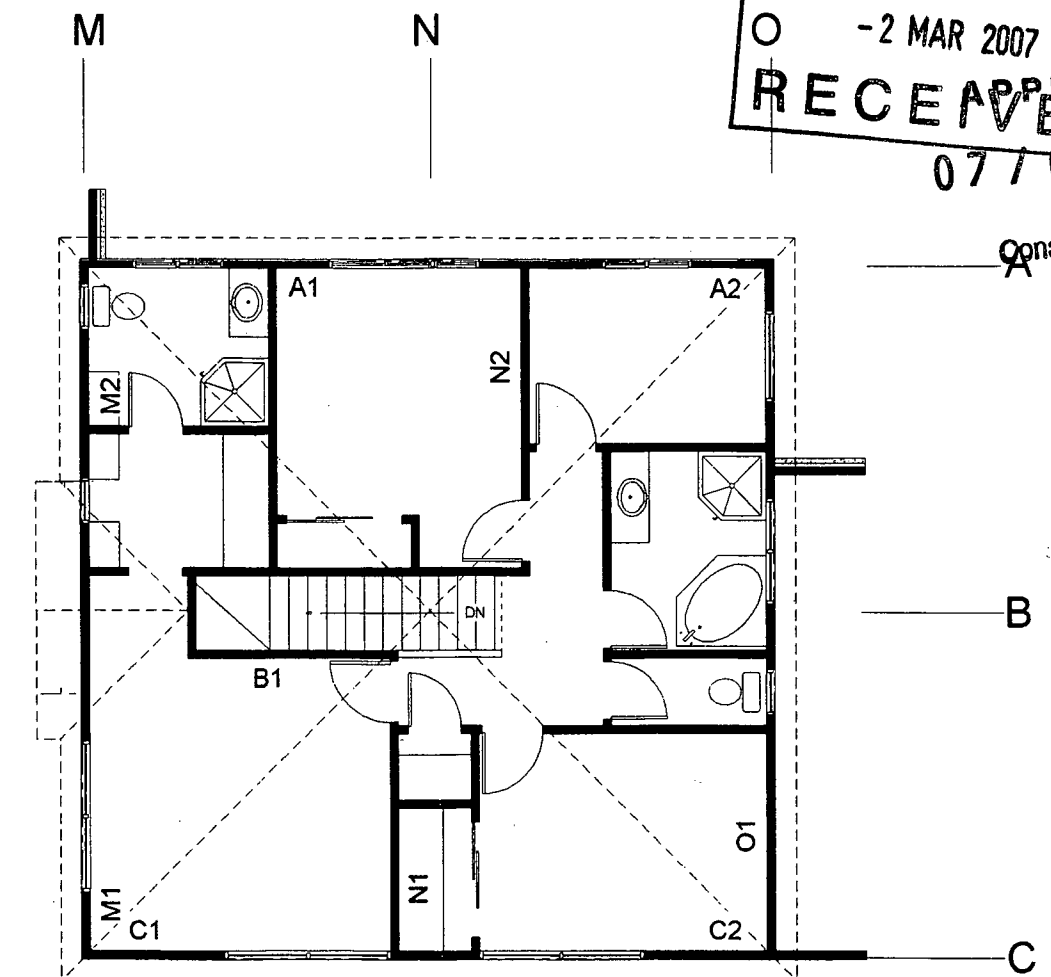

UPPER FLOOR

AREA 87 m2

HOUSE A

BASELINE CONSTRUCTION, 151 GREAT NORTH RD, WANGANUI



Architectural
Draughting
Centre

Herman de Jonge

54 Holmwood Road, Kaitoke, RD 2, Wanganui
Ph/Fax 06 347 1994 Mobile 021 285 7233
hdejonge@xtra.co.nz Copyright 2000 : ADC

23 FEBRUARY 07

8