


Subilee Flats

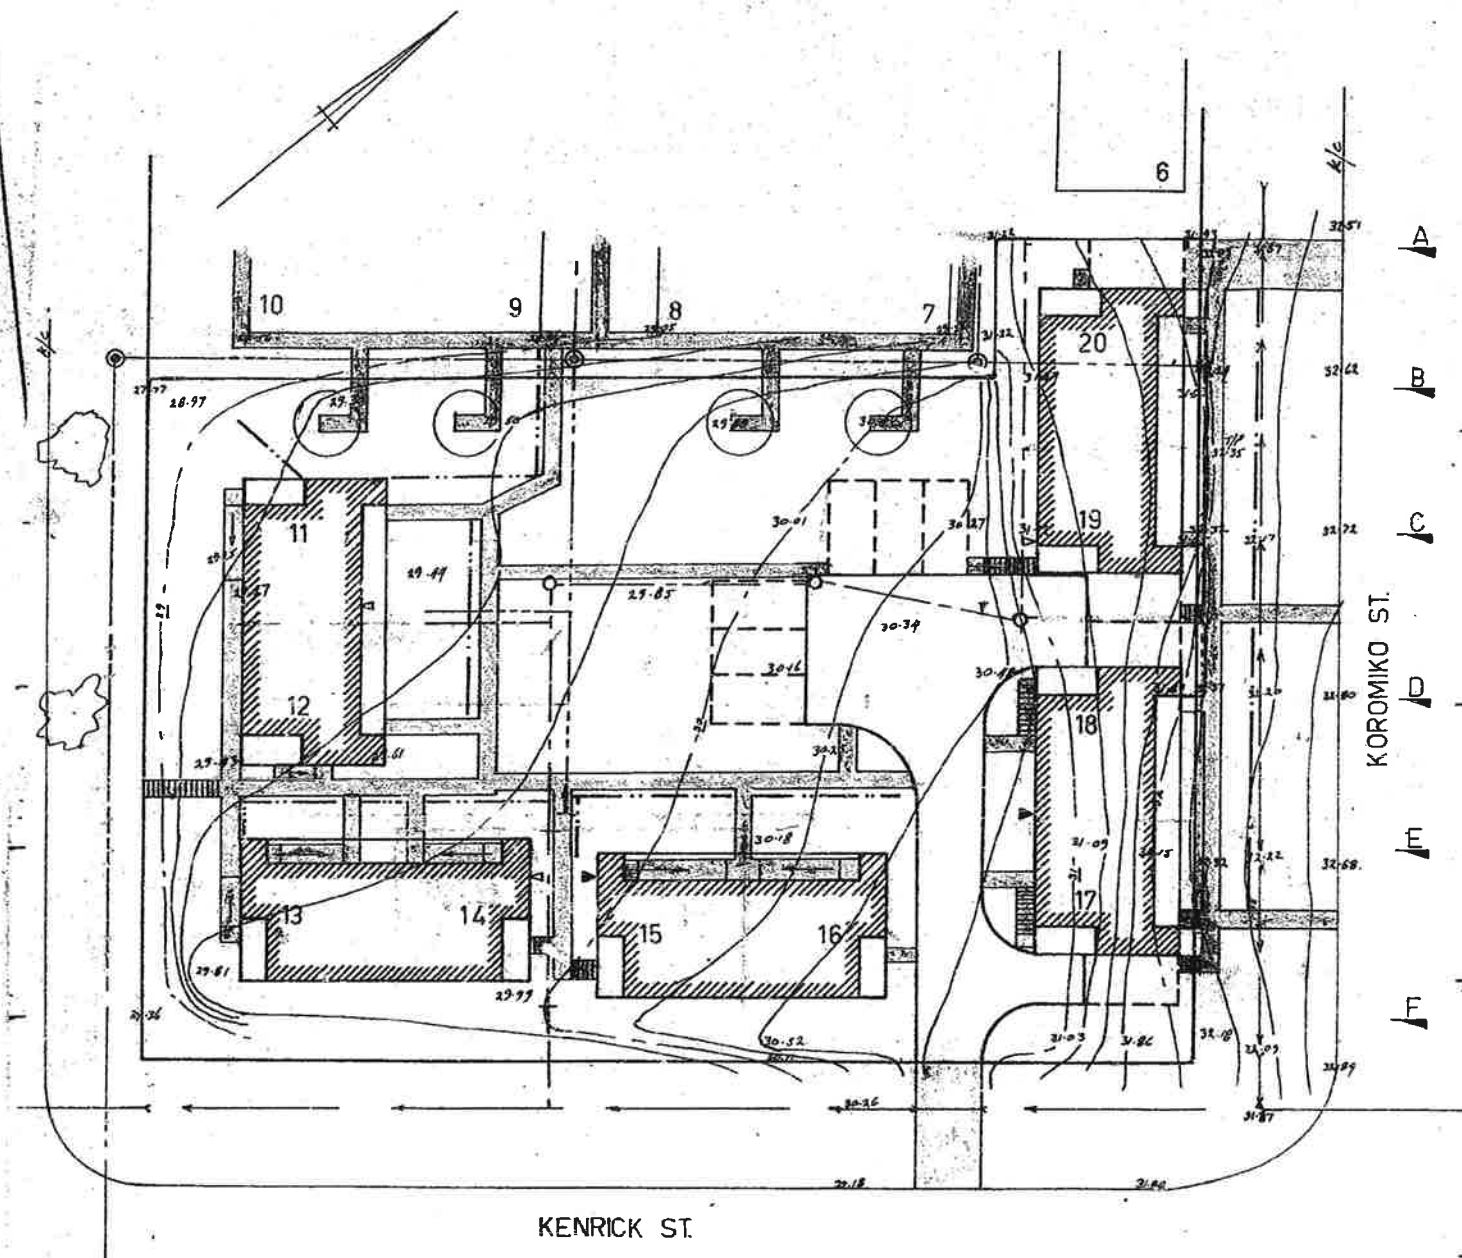

KOROMIKO ST.

KENRICK ST.

LEGEND

- Sanitary Sewer ————
- Stormwater ————
- Screen Fence ————
- Conc. Path ————
- Power Inlets ————
- " Distrib. Board ————

NOTE:

Water & P.O. Cable Laid
in S/S Trench.
Contractor to Check on
Location of Power Cable.
See sheet 2 for as built of U/G services

SURVEYED	MB	7/77
DRAWN	MB	7/77
DESIGNED	MB	8/77
TRACED	MB	8/77
CHECKED	KM	9/77
APPROVED		
REFERENCES		

PIAKO COUNTY COUNCIL		
P.O. BOX 26 TE AROHA		
F.W. Norton COUNTY ENGINEER		
AMENDMENTS	INITIAL	DATE

SILVER JUBILEE FLATS
SITE PLAN
STAGE II

SHEET No. 1
OF 6 SHEETS
P.C.C.982
SCALES
1:250

ORIGINAL LINE LENGTH BEFORE REDUCTION - 250MM

APPROVED
F.W. Norton
COUNTY ENGINEER