


CHURCH ST.

A
B
C
D
E
F

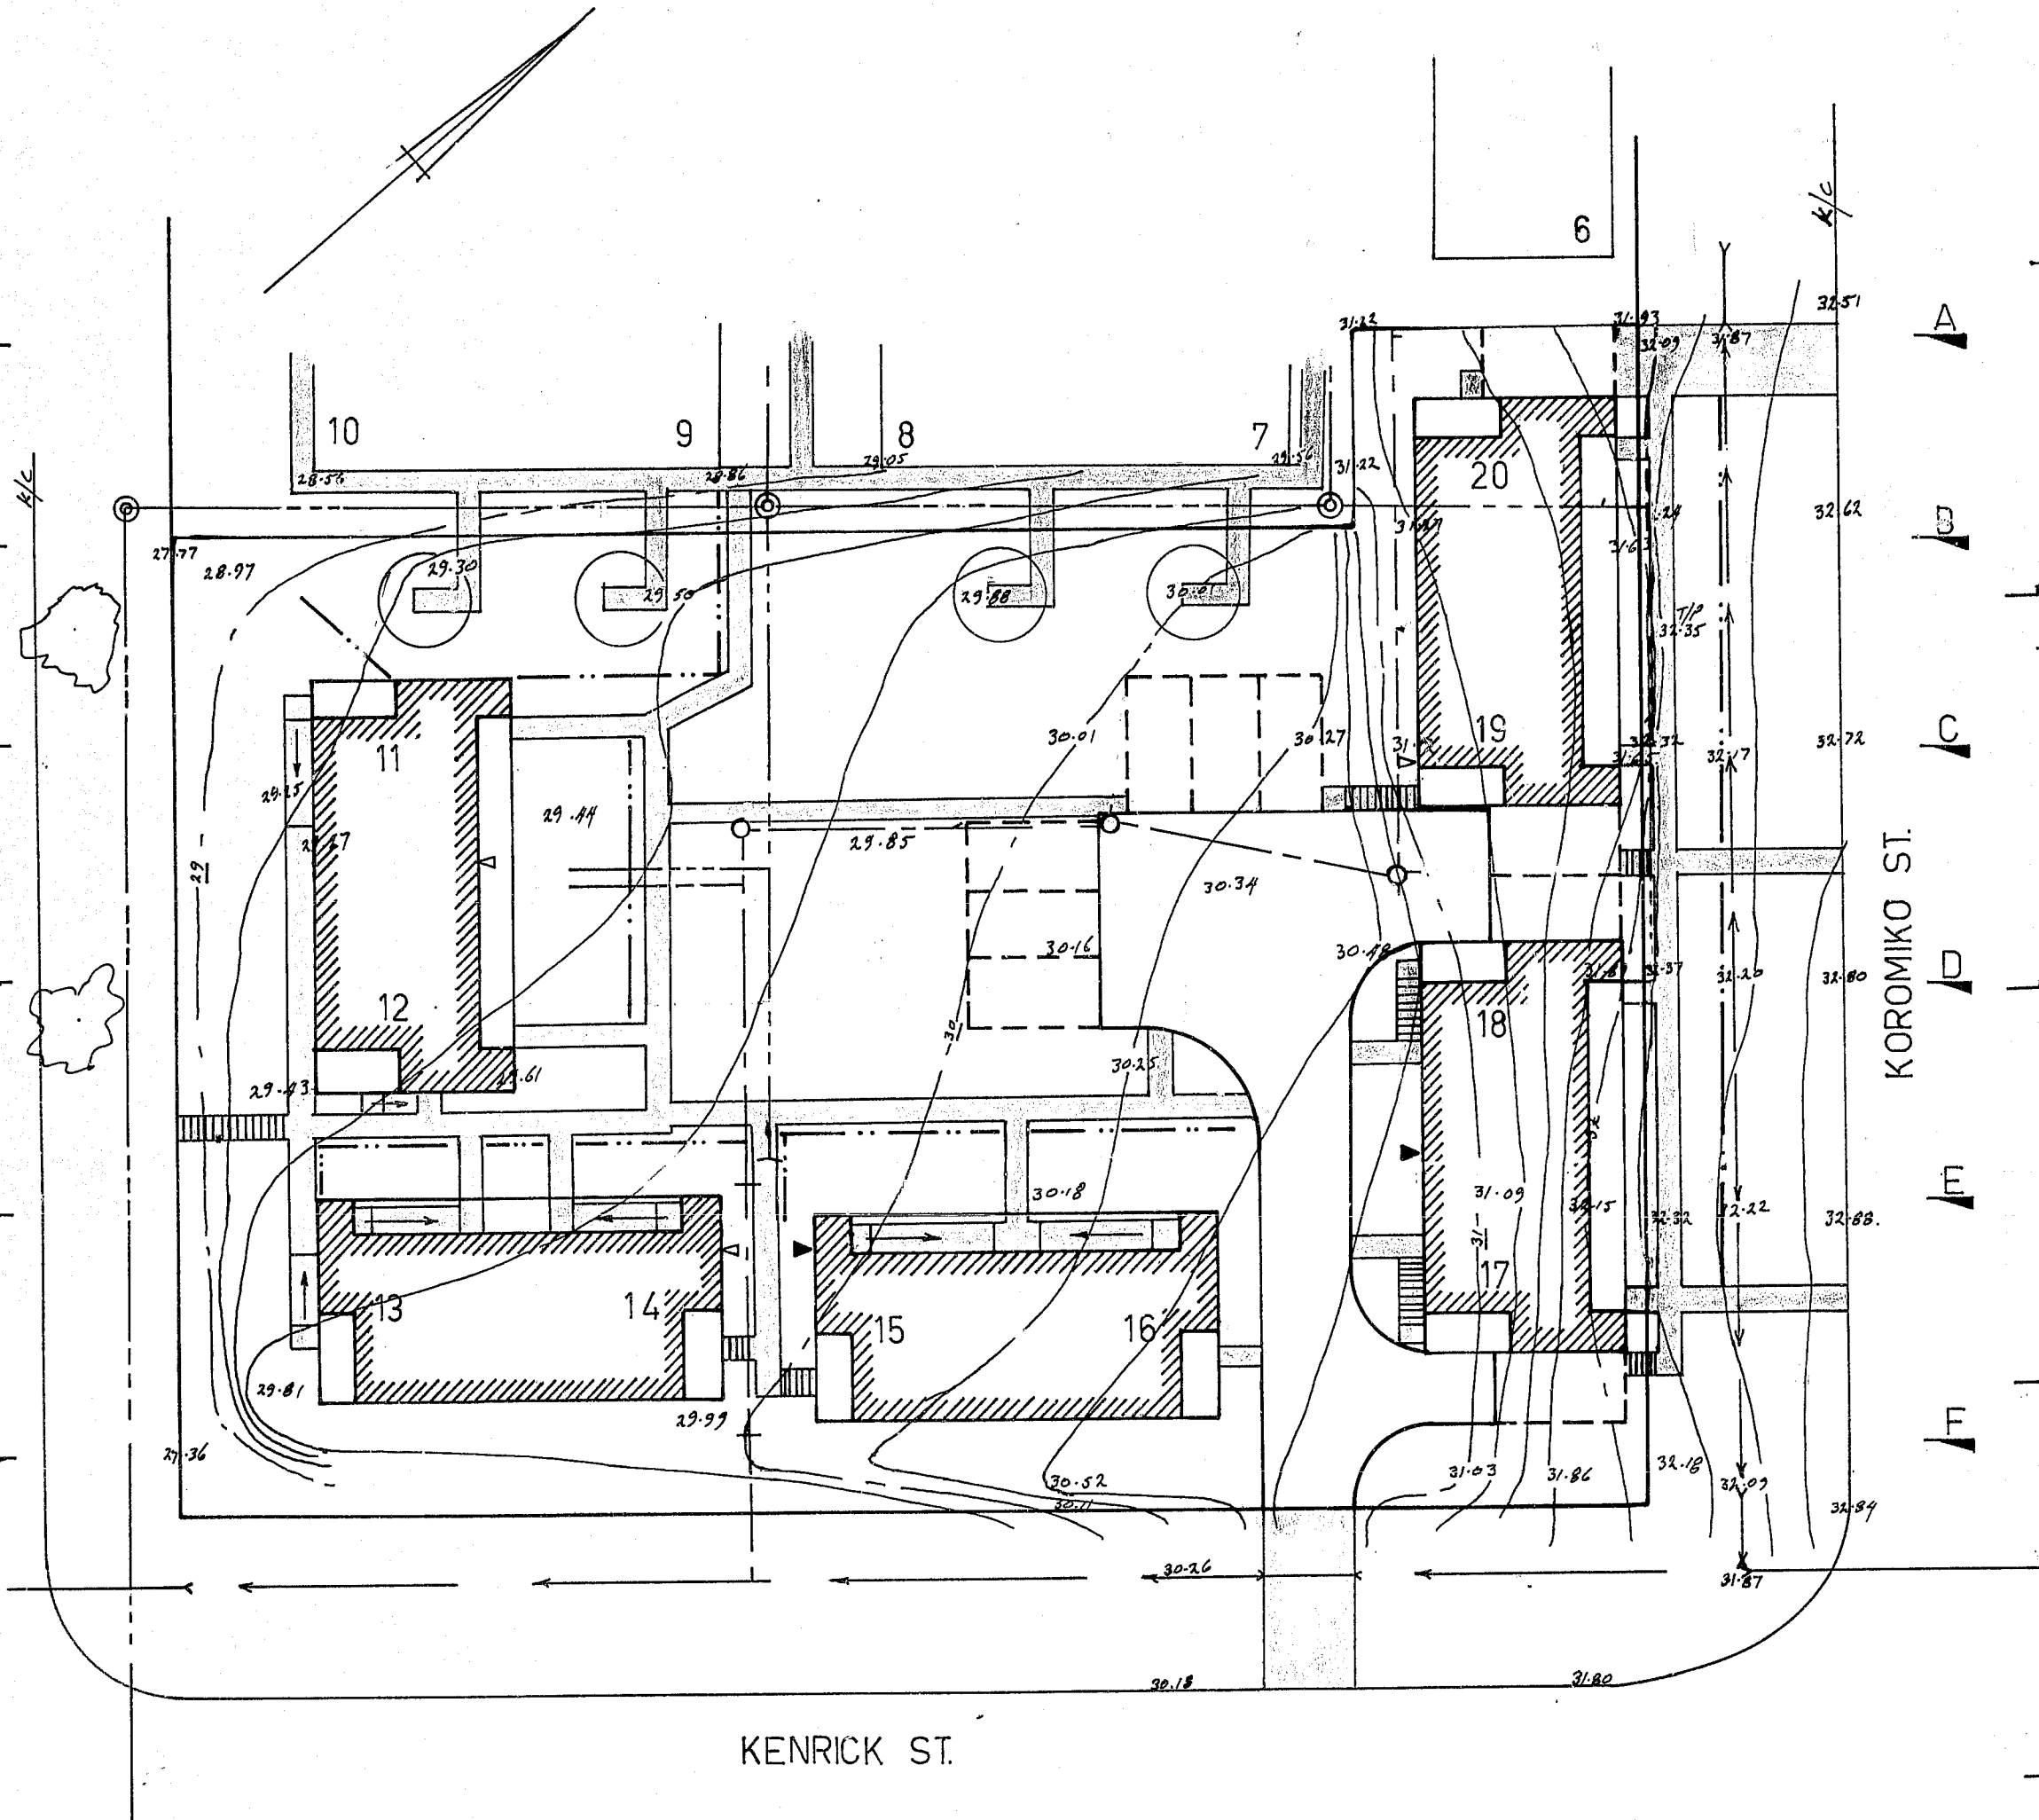

KOROMIKO ST.

KENRICK ST.

LEGEND

Sanitary Sewer -----
Stormwater -----
Screen Fence -----
Conc. Path -----

Power Inlets ▴
" Distrib. Board ▴

NOTE:

Water & PO Cable Laid
in S/S Trench.
Contractor to Check on
Location of Power Cable.
See sheet 2 for as built of U/G services

SURVEYED	7/77
DRAWN	7/77
DESIGNED	8/77
TRACED	8/77
CHECKED	9/77
APPROVED	
REFERENCES	

PIAKO COUNTY COUNCIL

P.O. BOX 26 TE AROHA
F.W. Norton COUNTY ENGINEER

AMENDMENTS	INITIAL	DATE

SILVER JUBILEE FLATS

SITE PLAN
STAGE II

SHEET No. 1
OF 6 SHEETS

P.C.C.982

SCALES
1:250

A-A H.A.D. 25m

B-B H.A.D. 25m

C-C H.A.D. 25m

D-D H.A.D. 25m

E-E H.A.D. 25m

F-F H.A.D. 25m

ORIGINAL LINE LENGTH 250m BEFORE REDUCTION

Microtech
P.O. Box 26
Te Aroha
Tel: 011 855 510