


Jubilee Flats

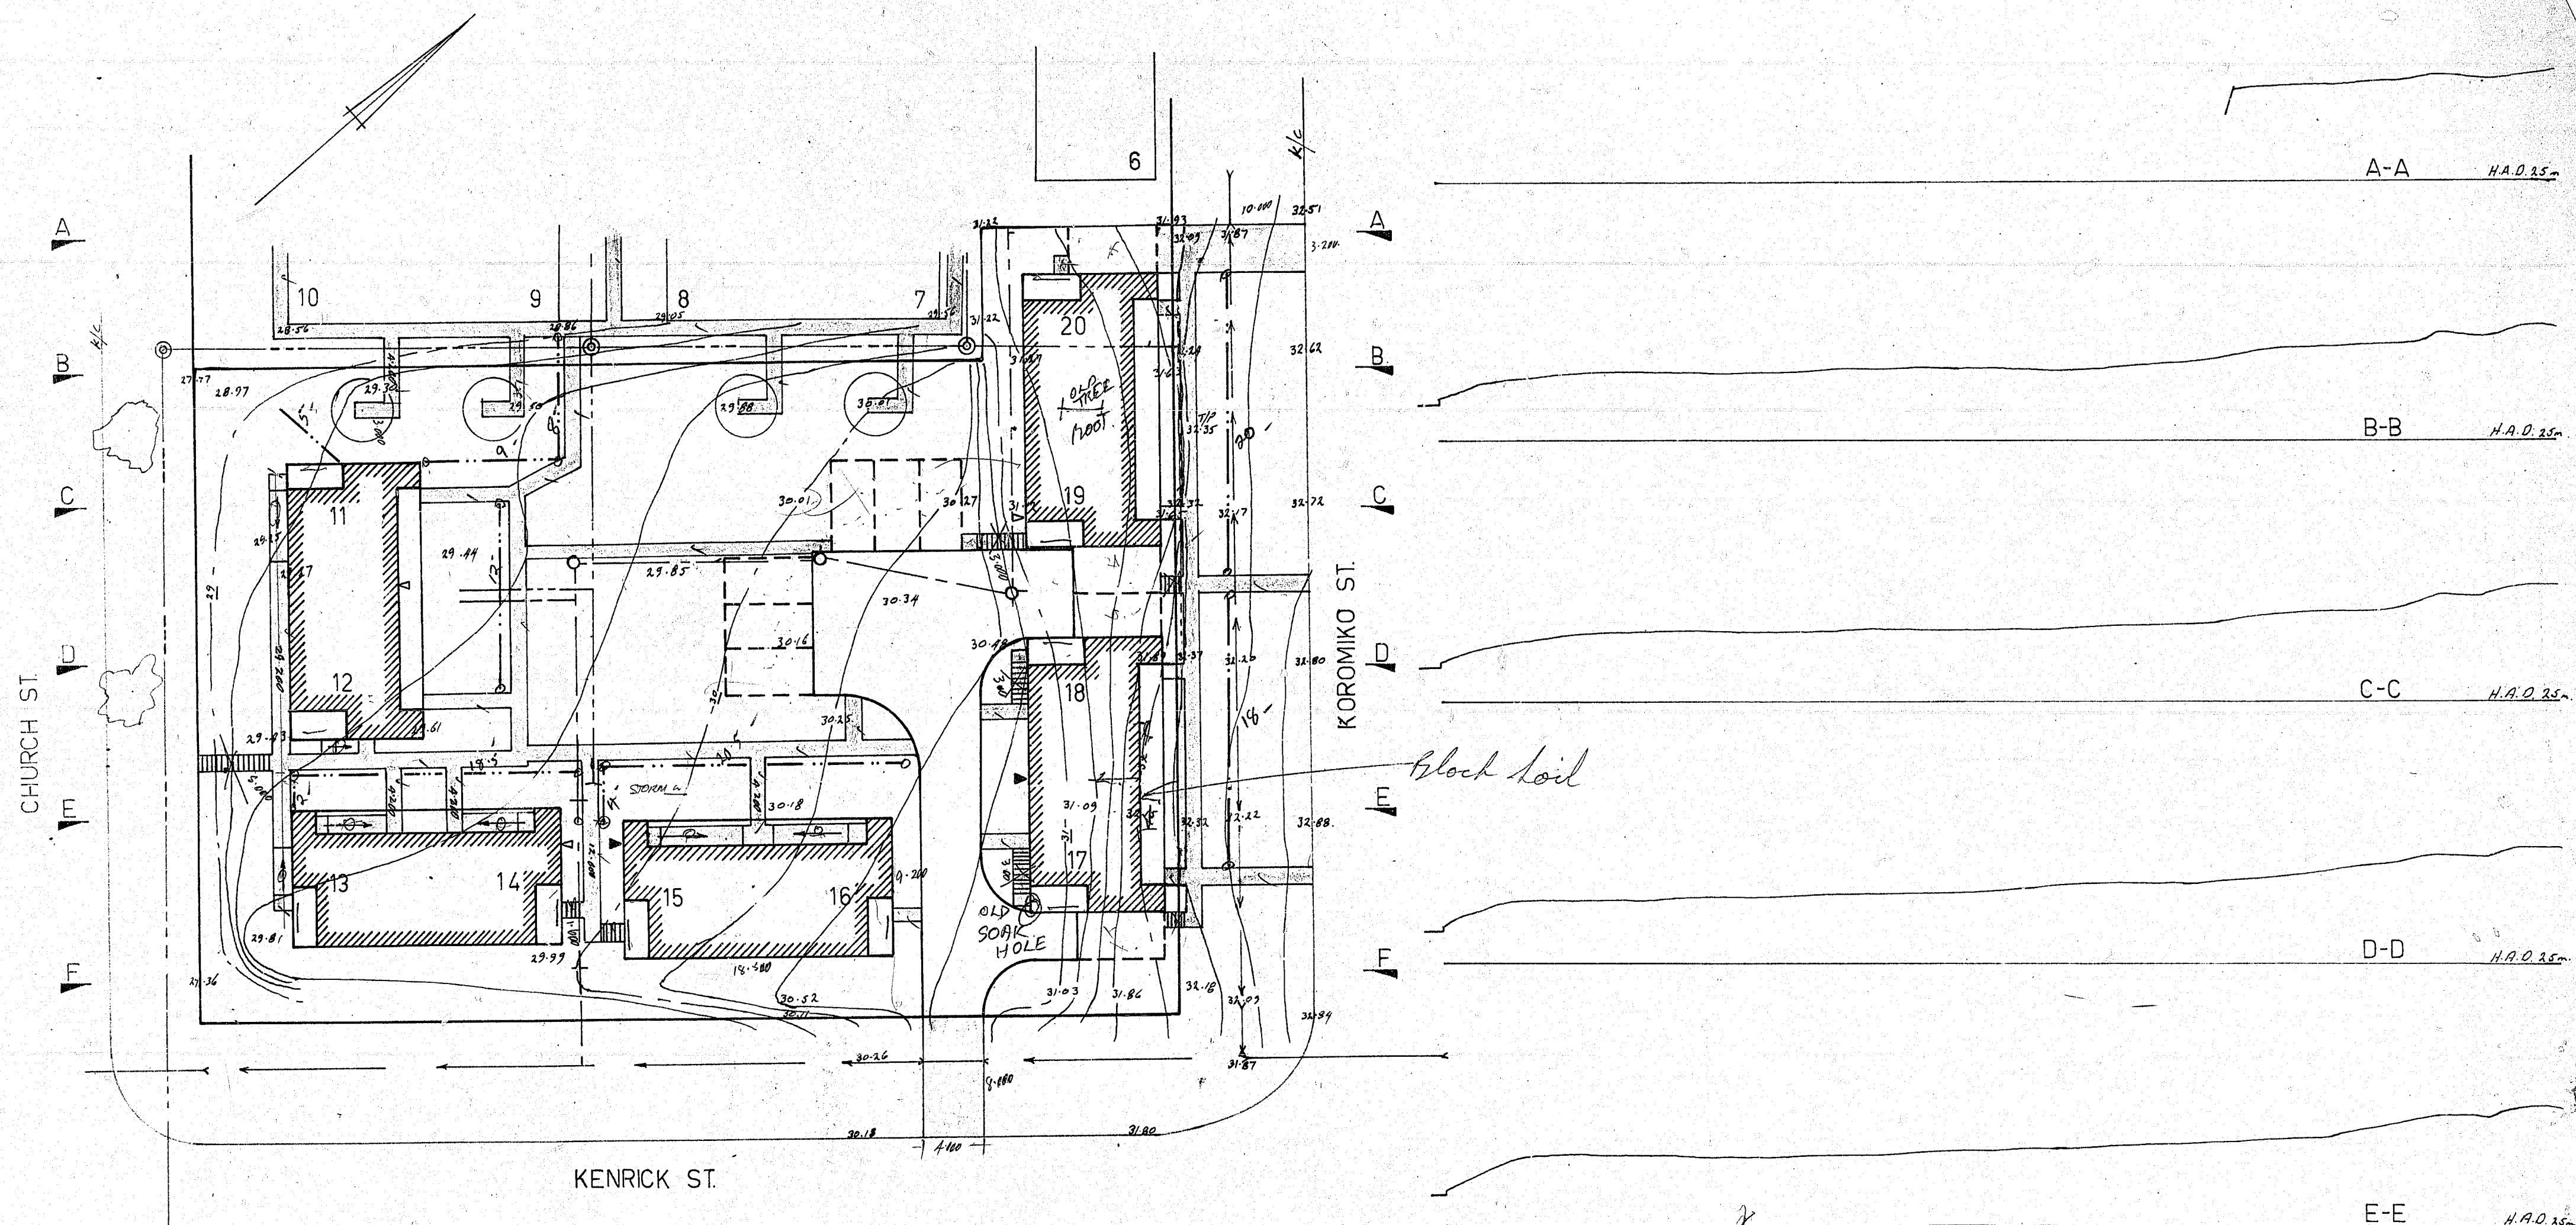

LEGEND

Sanitary Sewer ---
Stormwater ---
Screen Fence ---
Conc. Path ---

Power Inlets ▴
" Distrib. Board ▴

NOTE:

Water & P.O. Cable Laid
in S/S Trench.
Contractor to Check on
Location of Power Cable.
See sheet 2 for as built of U/G services

Forcing 20
18
20.5
4
1.8.5
7
17
12
117.0
7

SURVEYED	2/77	7/77
DRAWN	2/77	7/77
DESIGNED	2/77	8/77
TRACED	2/77	8/77
CHECKED	2/77	8/77
APPROVED	2/77	8/77
REFERENCES		

PIAKO COUNTY COUNCIL

P.O. BOX 26 TE AROHA

County Engineer

AMENDMENTS INITIAL DATE

SILVER JUBILEE FLATS

SITE PLAN

STAGE II

SHEET No. 1
OF 6 SHEETS

P.C.C.982

SCALES
1:250

ORIGINAL LINE LENGTH BEFORE REDUCTION - 250MM

Turnage Phone 95-340