

16mm 35mm

BUILDING FILE

Code No. 313 / 10

Subject DWL

No. Sheets 3

Permit No

Date 24.3.50


ADDITIONS
+
FISHER STOVES

23204





20882

21193

1

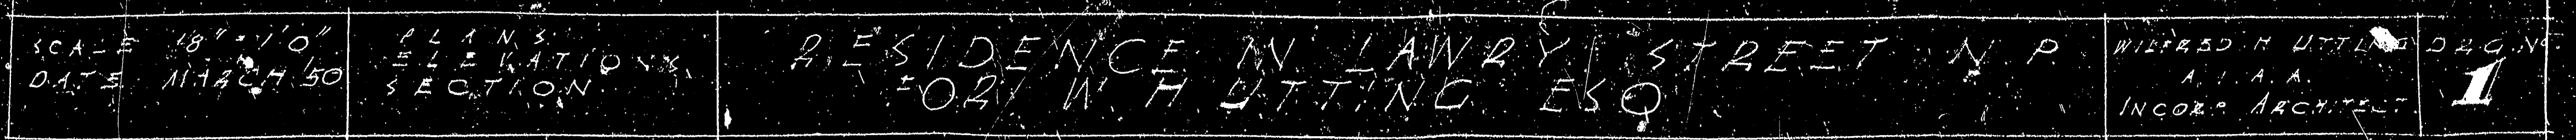


313/10

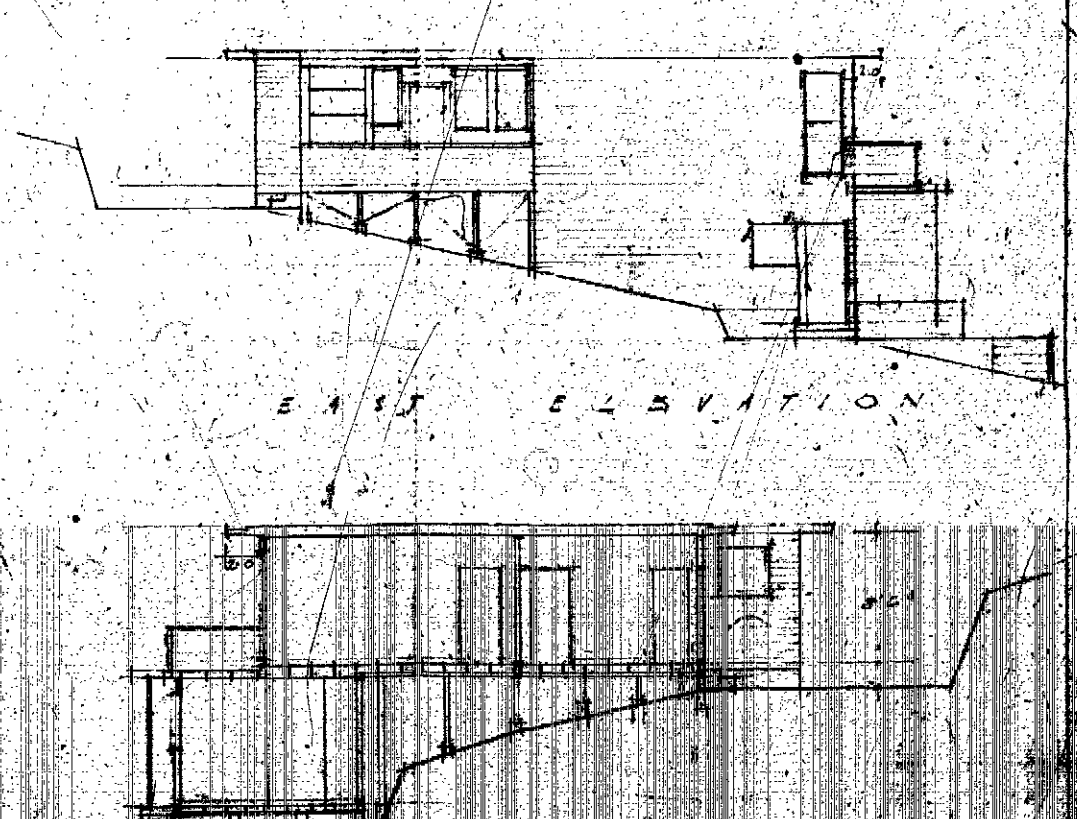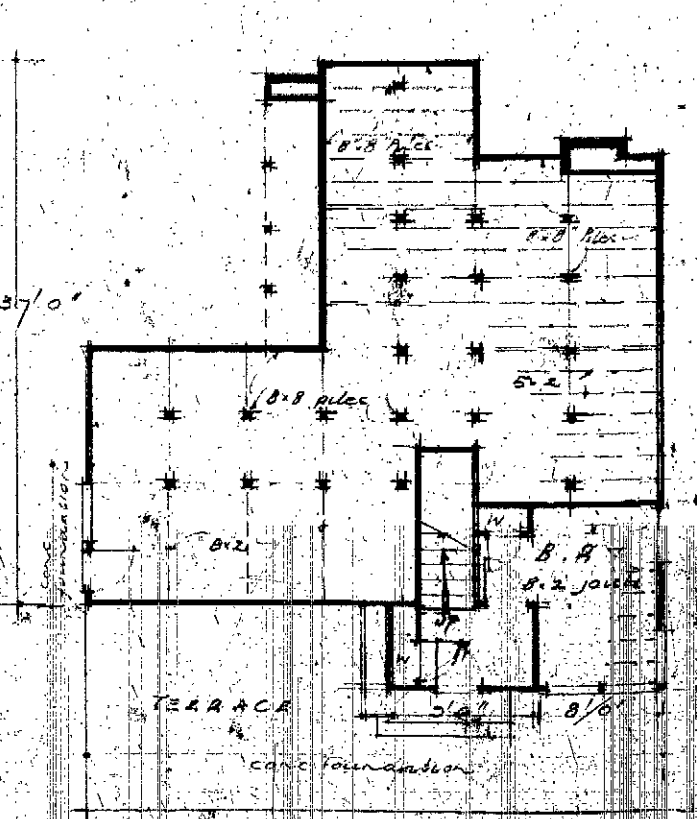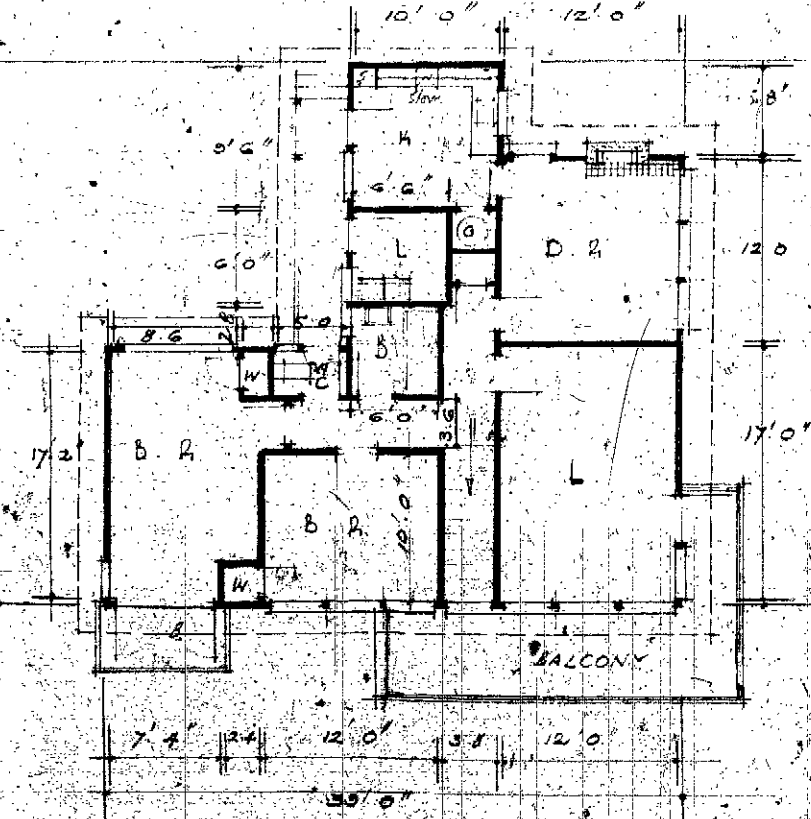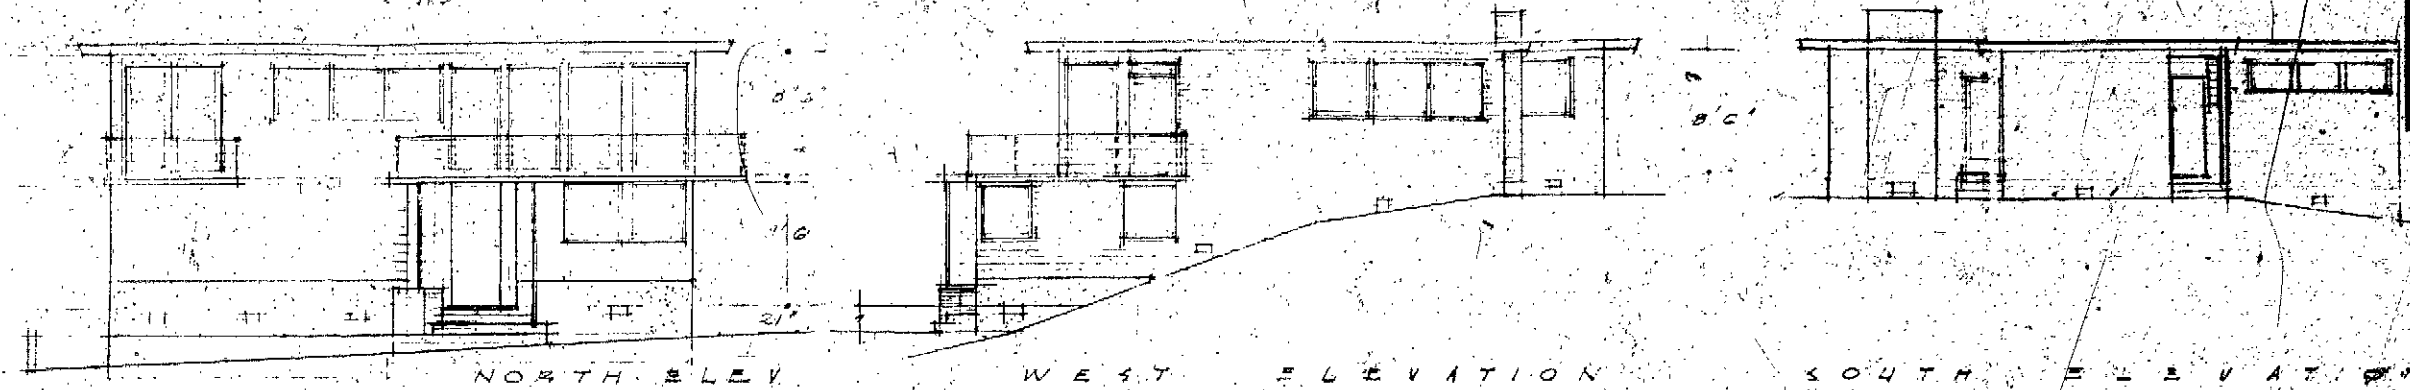

SCALE 1/8" = 1'-0"	PLANS	RESIDENCE IN LAUREY STREET N.P.	WILLIAM H. UTTING BORN
DATE MARCH 50	ELEVATIONS	FOR W. H. UTTING ESQ.	ARCHT.
	SECTION		INCORP. ARCHT.


313/10

F.L.P. Fluorescent Light Point
 L.P. Light Point
 B.L. Branch Line
 ! waterless fixture
 PP Power Point
 2WS Two Way Switch

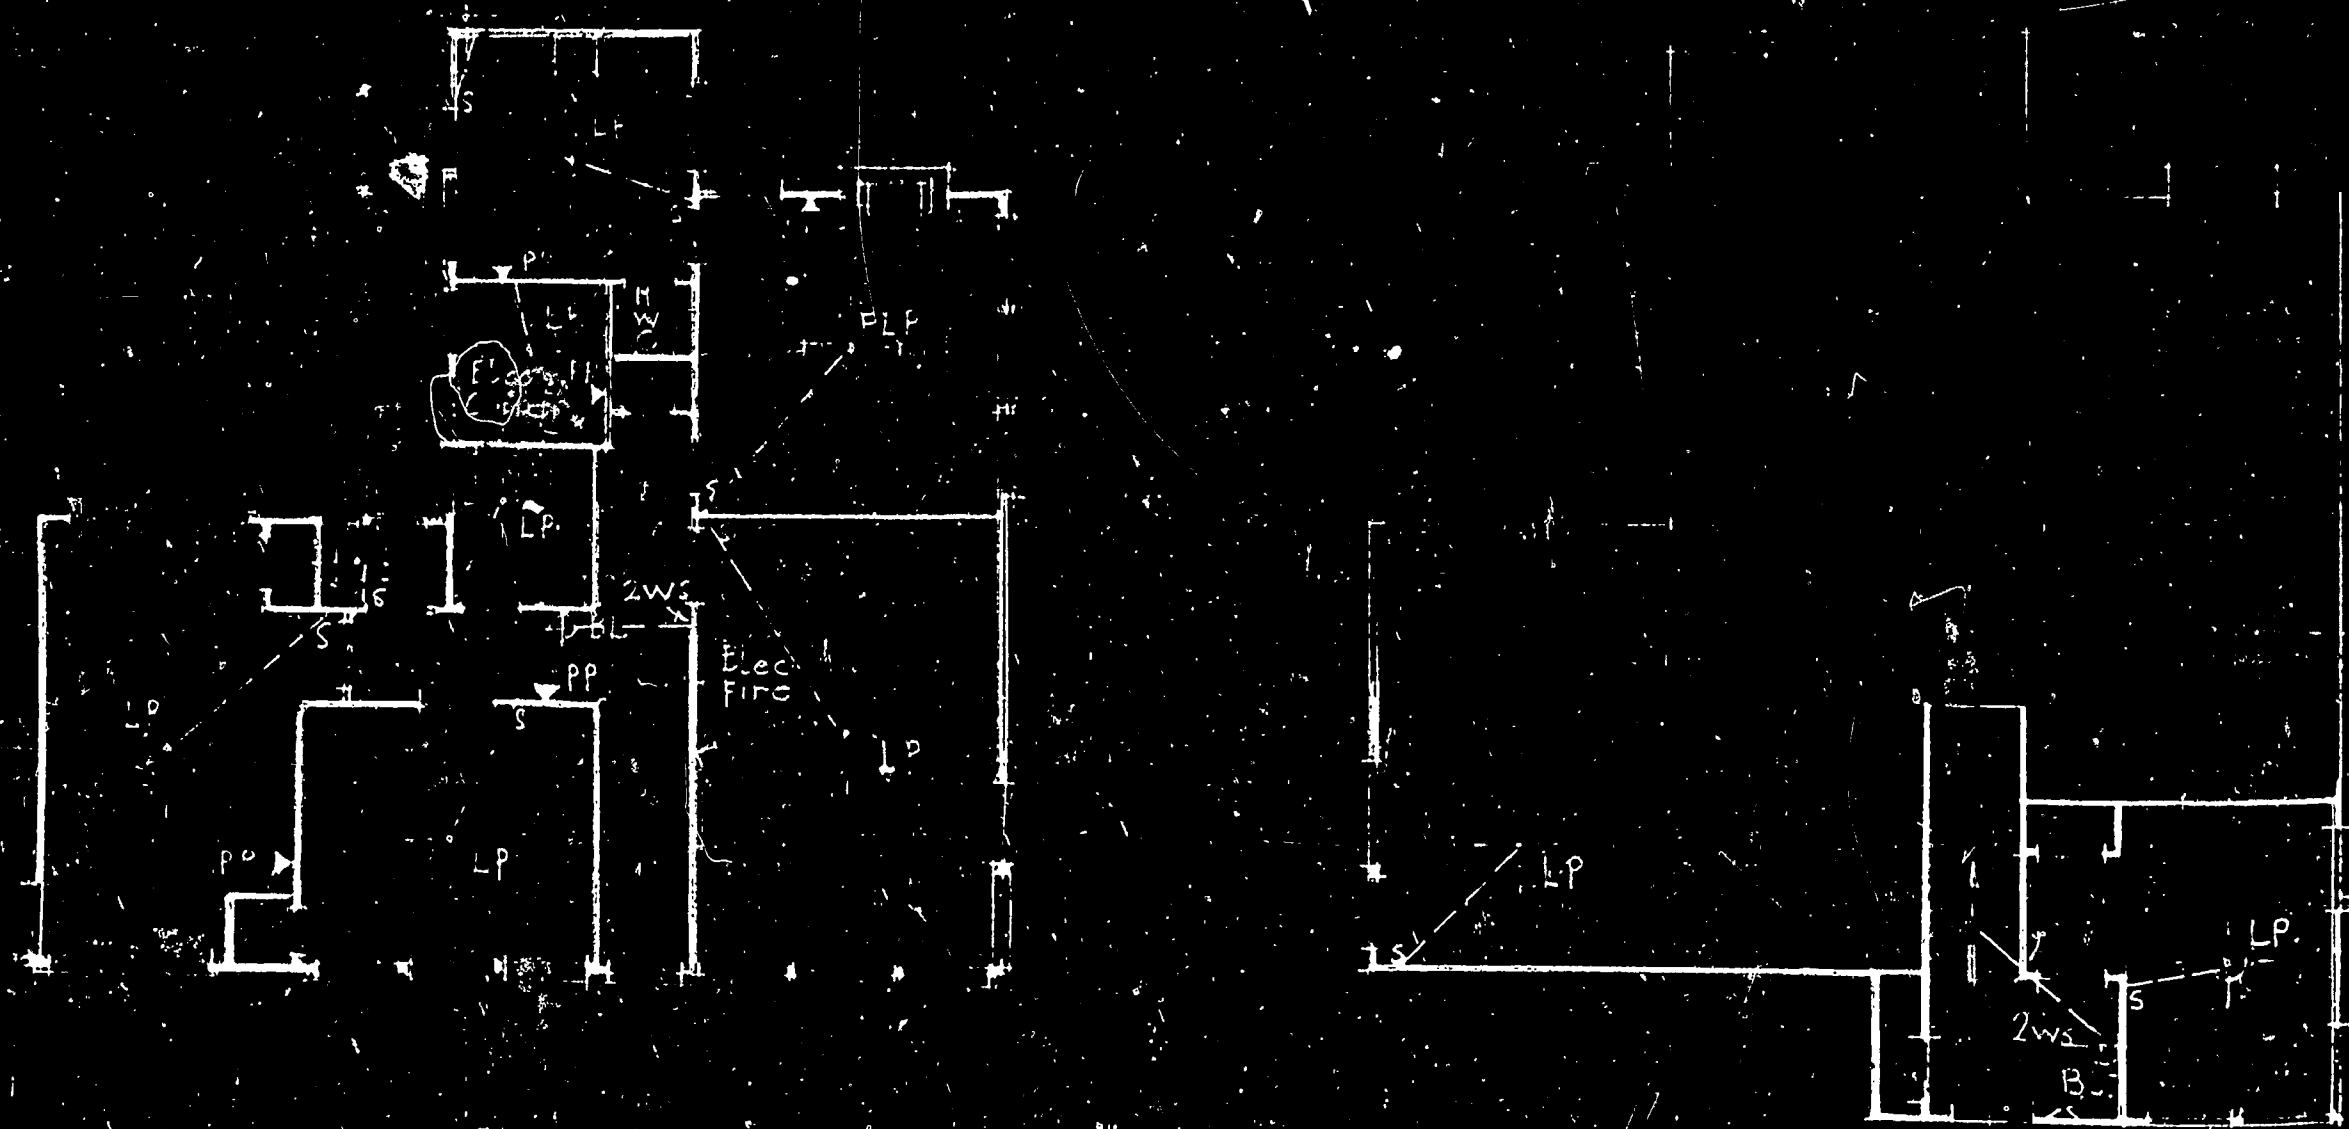

FIRST FLOOR GROUND FLOOR

ELECTRICAL LIGHTING PLAN

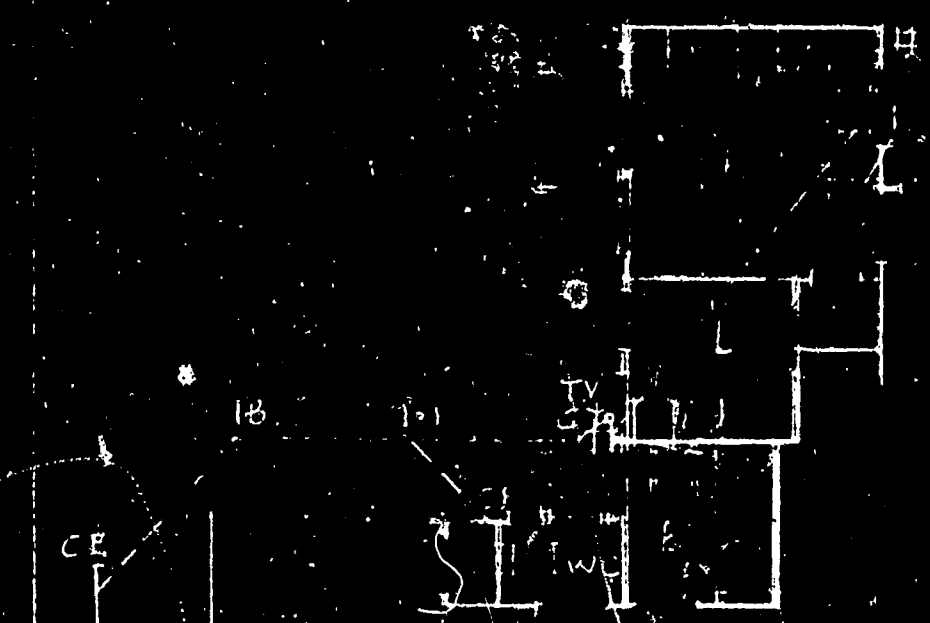


DAY IN


SCALE 1/4" = 1'-0"	DATE 11-10-50	DESIGNED BY	RESIDENCE IN LAMAR STREET	NO. 2
MADE BY	11-10-50	PLAN	FOR WASHINGTON ESQ	

313/10


- LEGEND**
- FLP Fluorescent Light Point
 - LP Light Point
 - B.L. Switch Light Point
 - WLF Water Light Fitting
 - PP Power Point
 - WS Two-way Switch

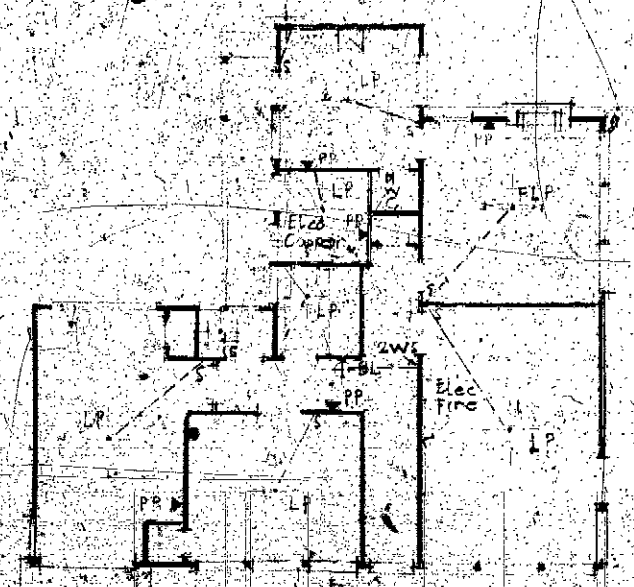

FIRST FLOOR

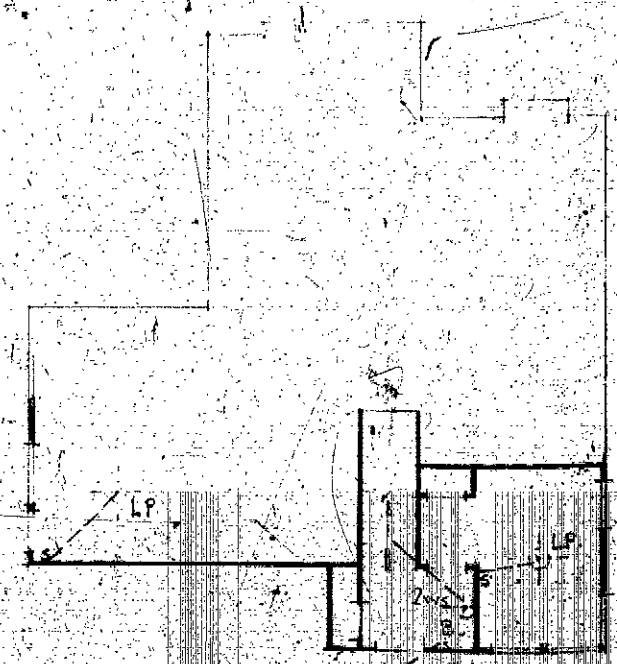

GROUND FLOOR

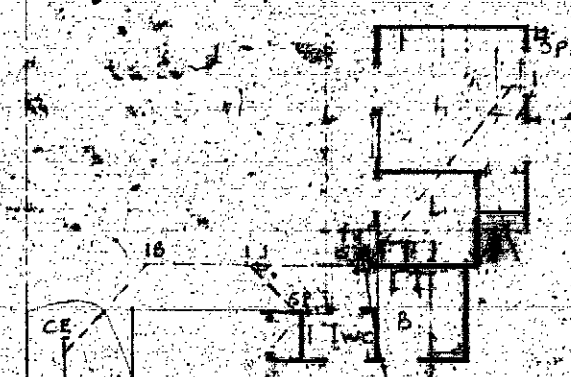


DRAINAGE PLAN






SCALE 1/8" = 1'-0" ELEC. PLAN 1/4" = 1'-0" PLUMBING PLAN
 NORTH ARROW
 RESIDENCE IN LINDSEY STREET NO. 10
 FOR W. H. LITTLE ESQ.
 1910



313/10 7 95
28 JUL 1992


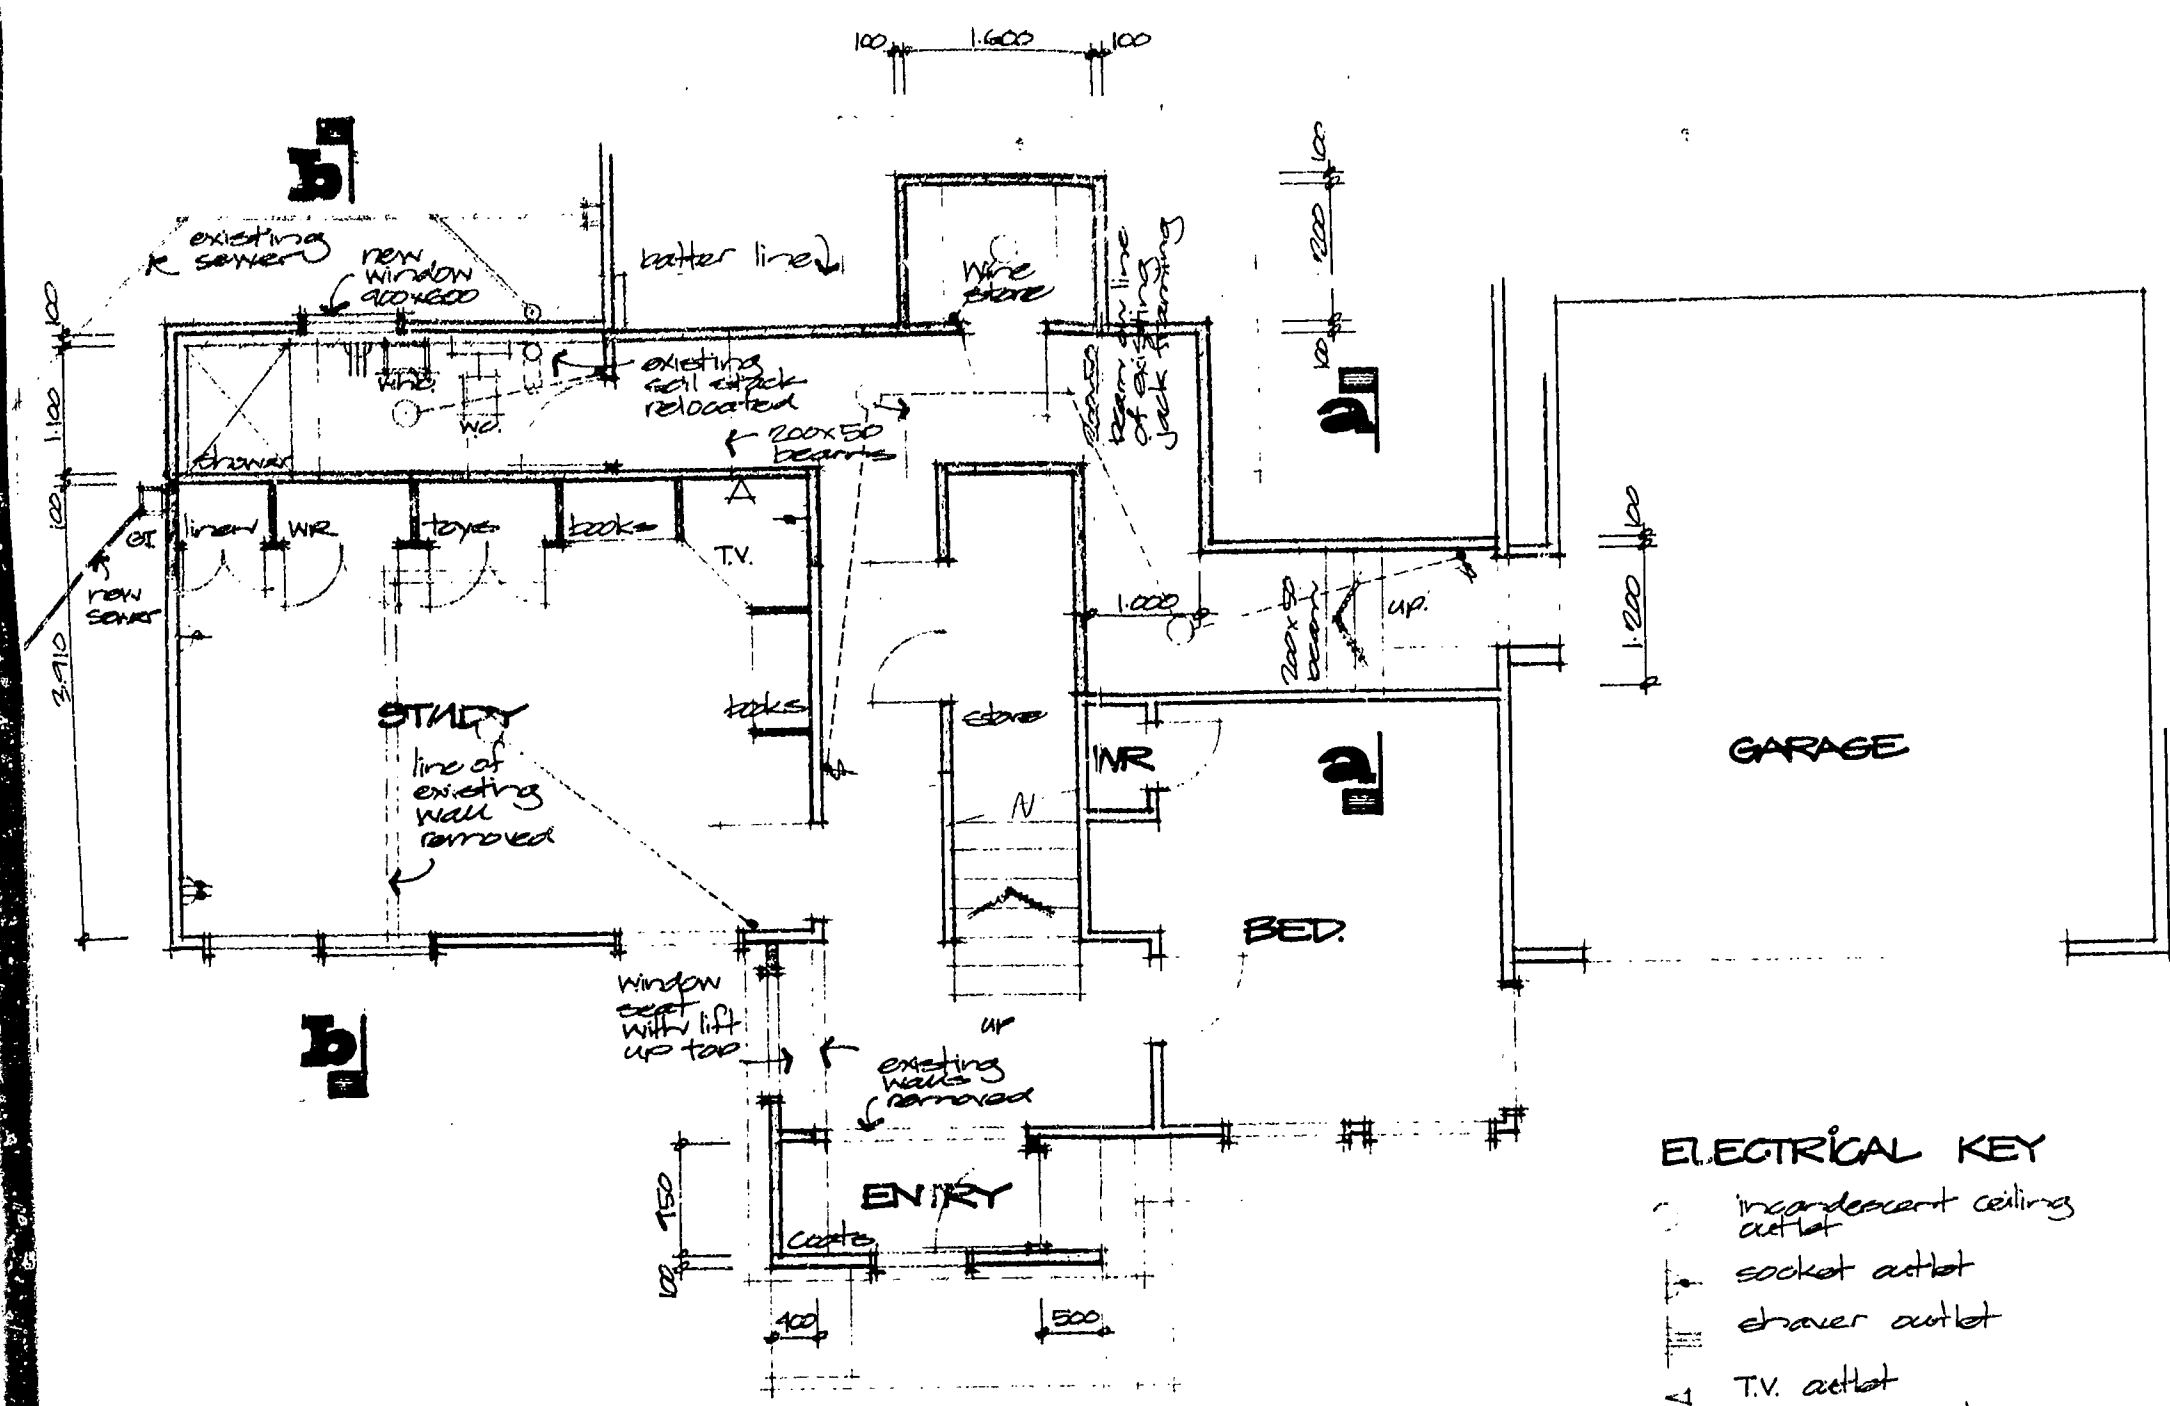


- ELECTRICAL KEY**
- independent ceiling outlet
 - socket outlet
 - shaver outlet
 - T.V. outlet
 - one way switch
 - two way switch

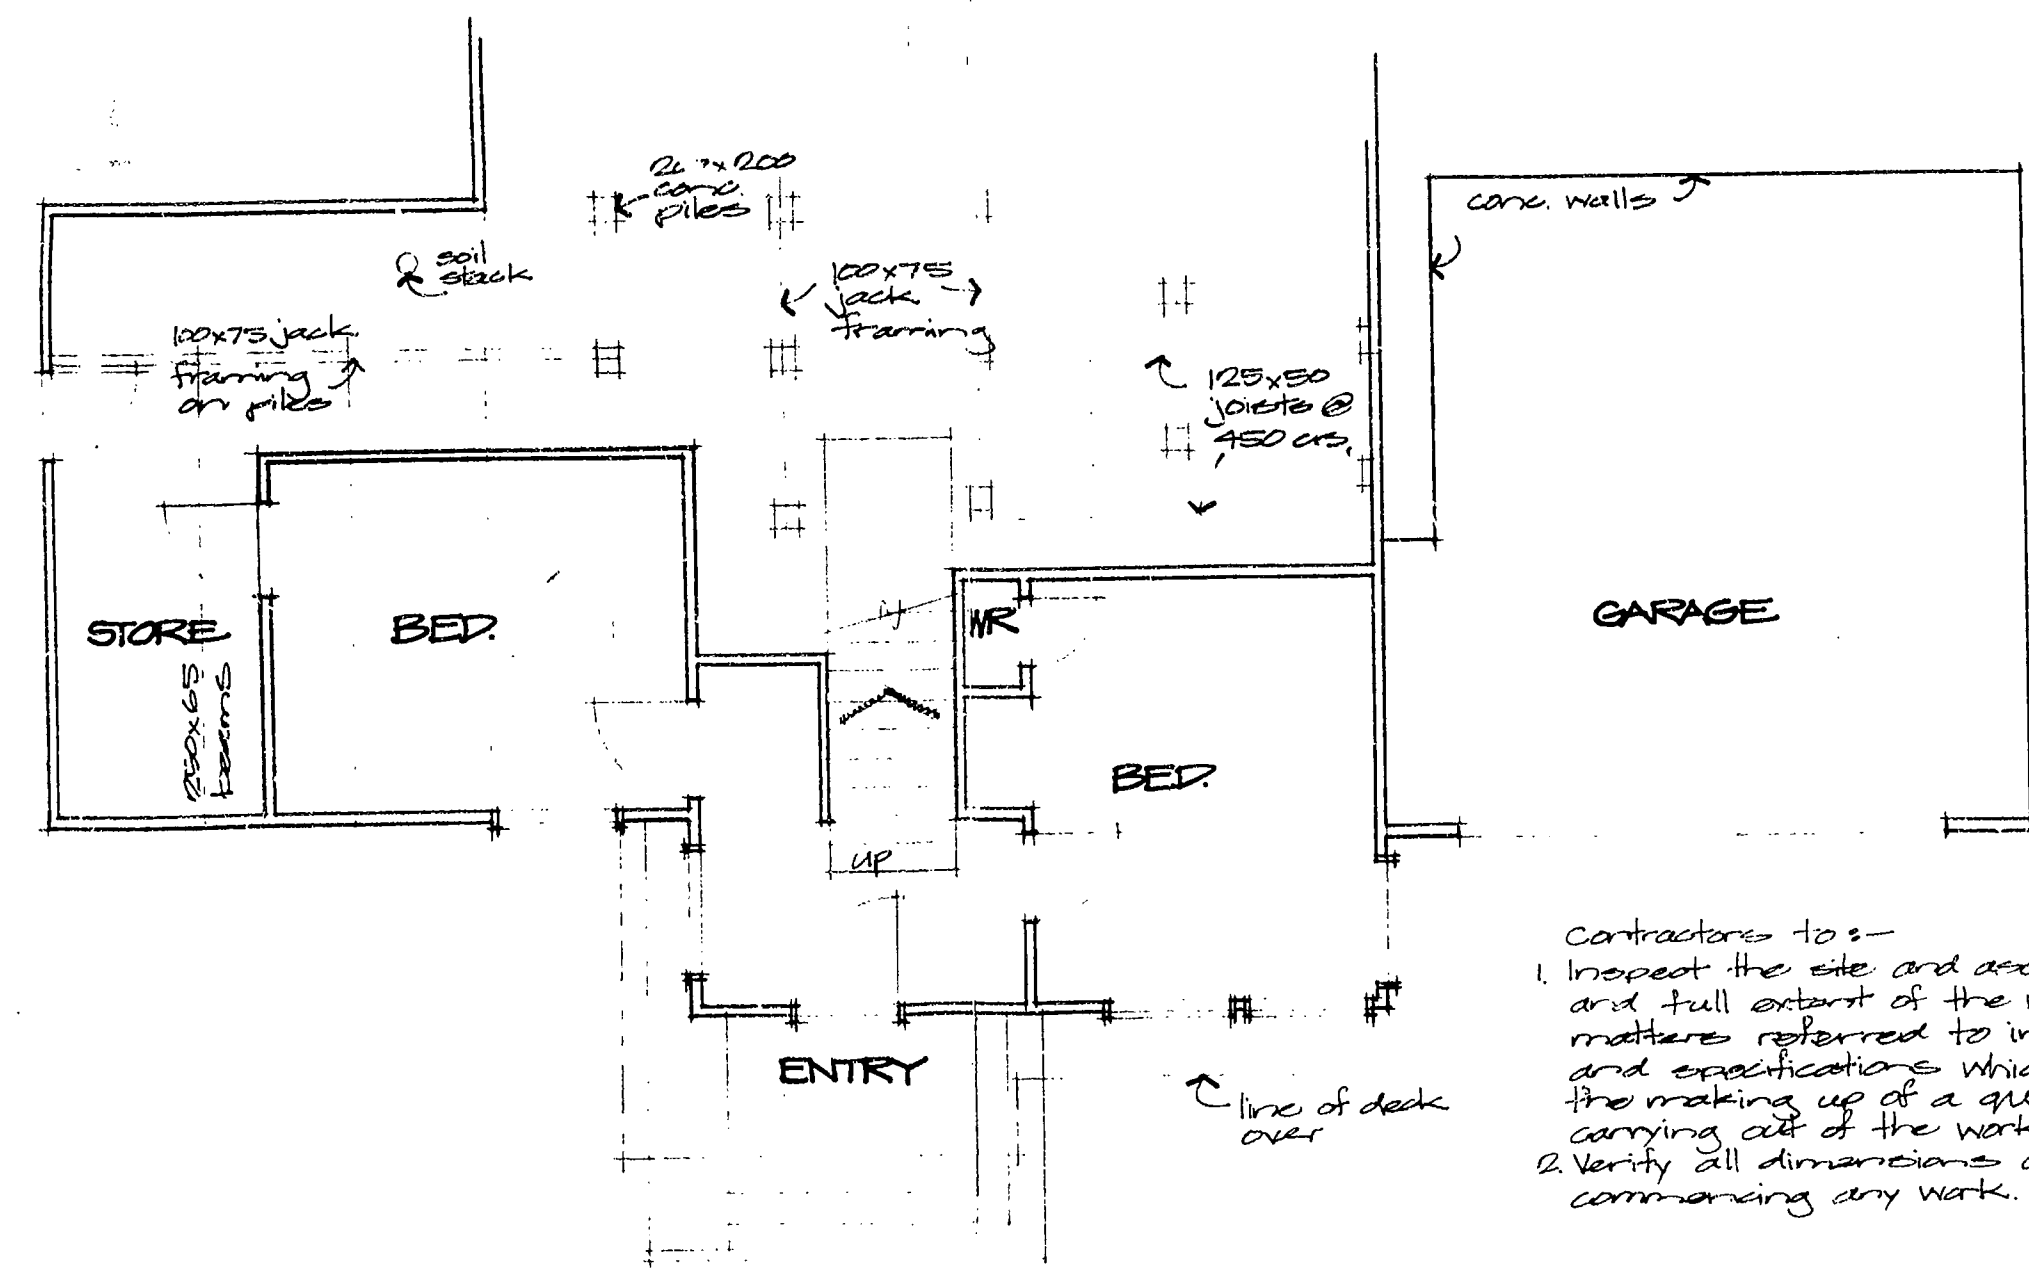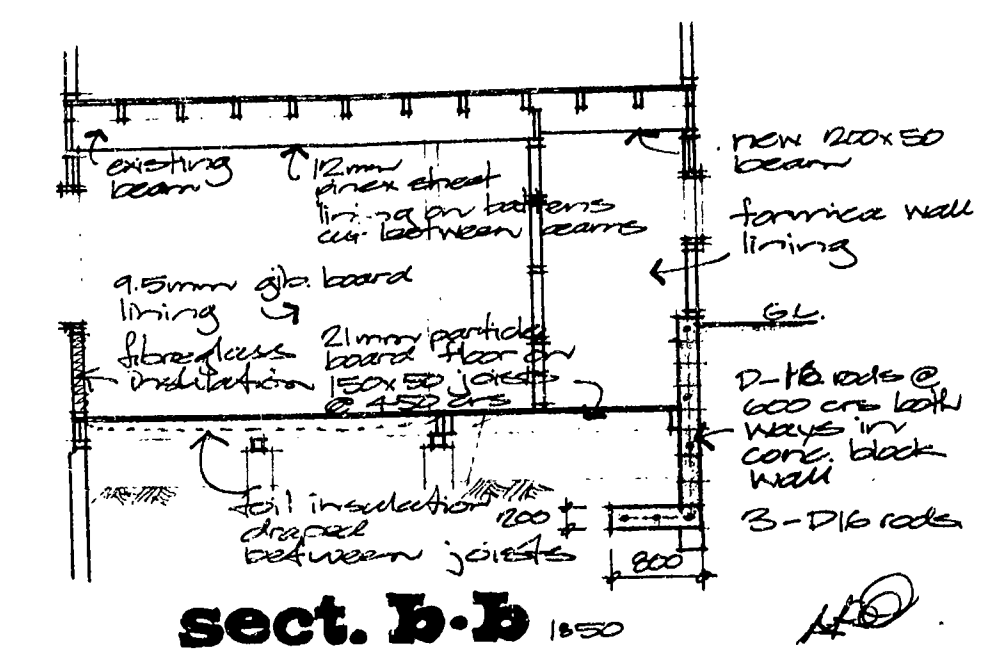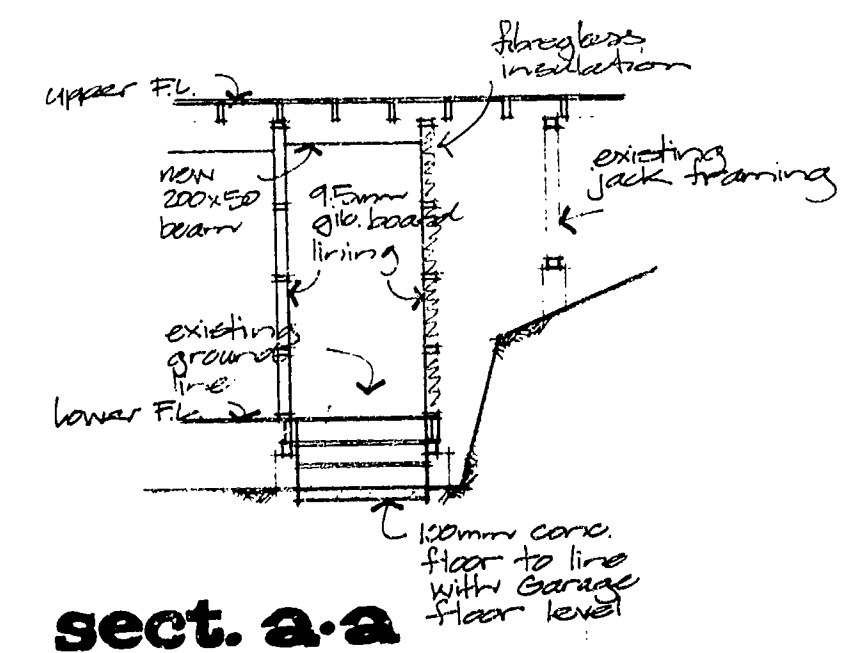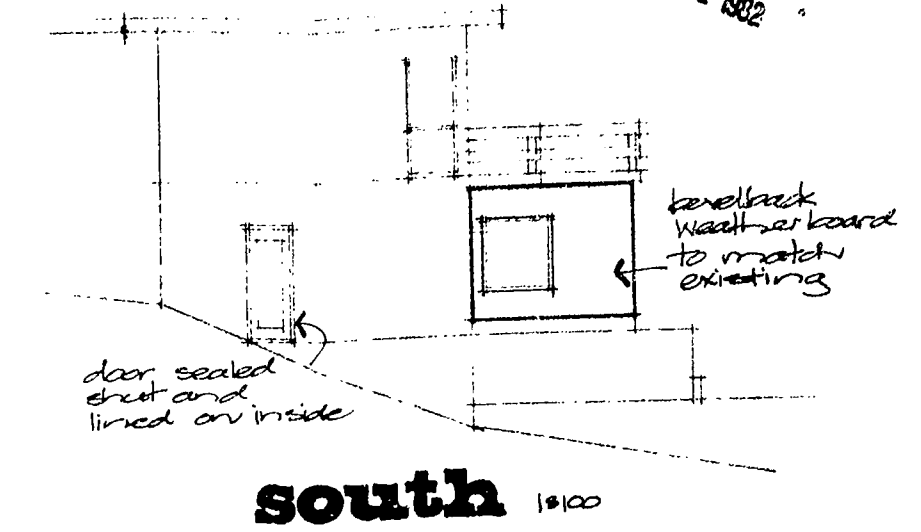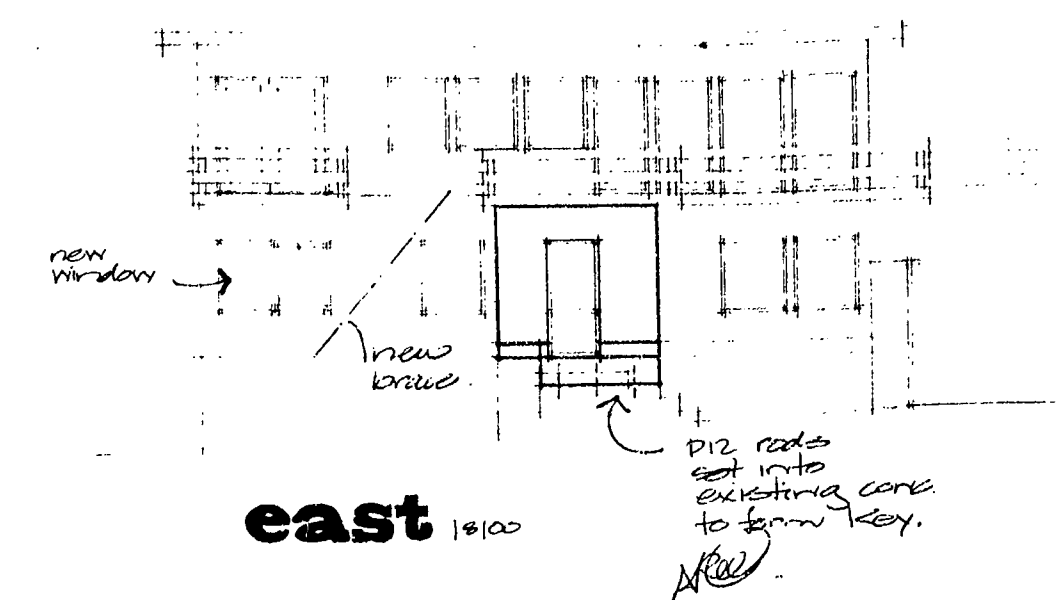

Contractors to:-

1. Inspect the site and ascertain the nature and full extent of the work and all matters referred to in the plans and specifications which may influence the making up of a quotation to the carrying out of the work in its entirety.
2. Verify all dimensions on site before commencing any work.

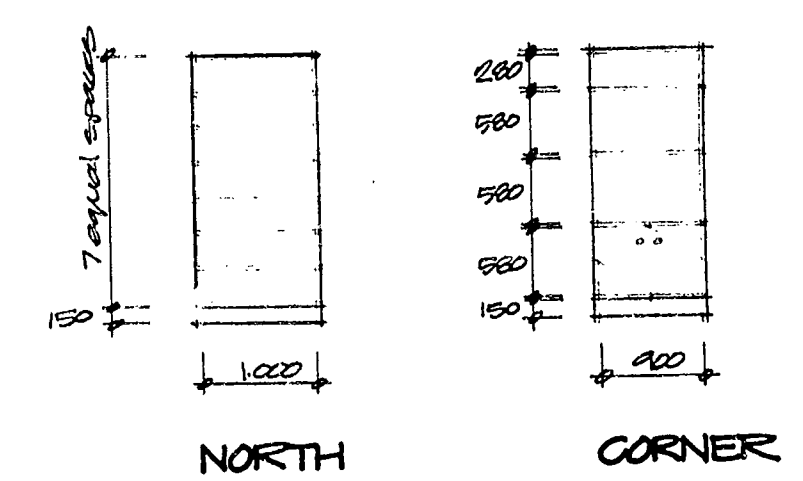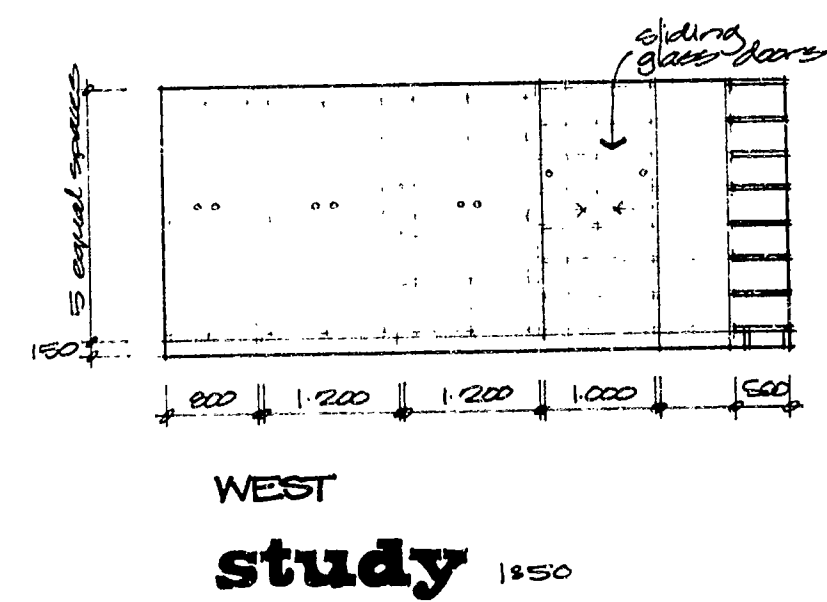


THIS IS A PARTIAL TITLE SITE
NOT APPROVED

NEW PLYMOUTH CITY COUNCIL
PLANS AND SPECIFICATIONS APPROVED FOR TYPE, USE, SITING, COVER AND CONSTRUCTION AS IN ACCORDANCE WITH ALL RELEVANT REGULATIONS AND BYLAWS ADMINISTERED BY THE NEW PLYMOUTH CITY COUNCIL.

TOWN PLANNING	DATE
PUBLIC HEALTH	16.4.82
WATER	9.8.82
WASTE PLANS AND SPECIFICATIONS ARE THE PROPERTY OF THE N.W. PLYMOUTH CITY COUNCIL AND ARE NOT TO BE REPRODUCED OR USED FOR ANY OTHER PURPOSE.	

VERIFYING TO BE COMPLETED BY 16.10.1982

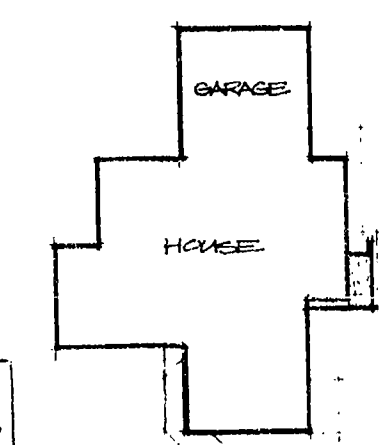

LAWRY STREET

SITE DESCRIPTION
Being Lots 4+5
D.P. 6622
C.T. F2/116 - C2/318
1618m² incl. R.O.W.