


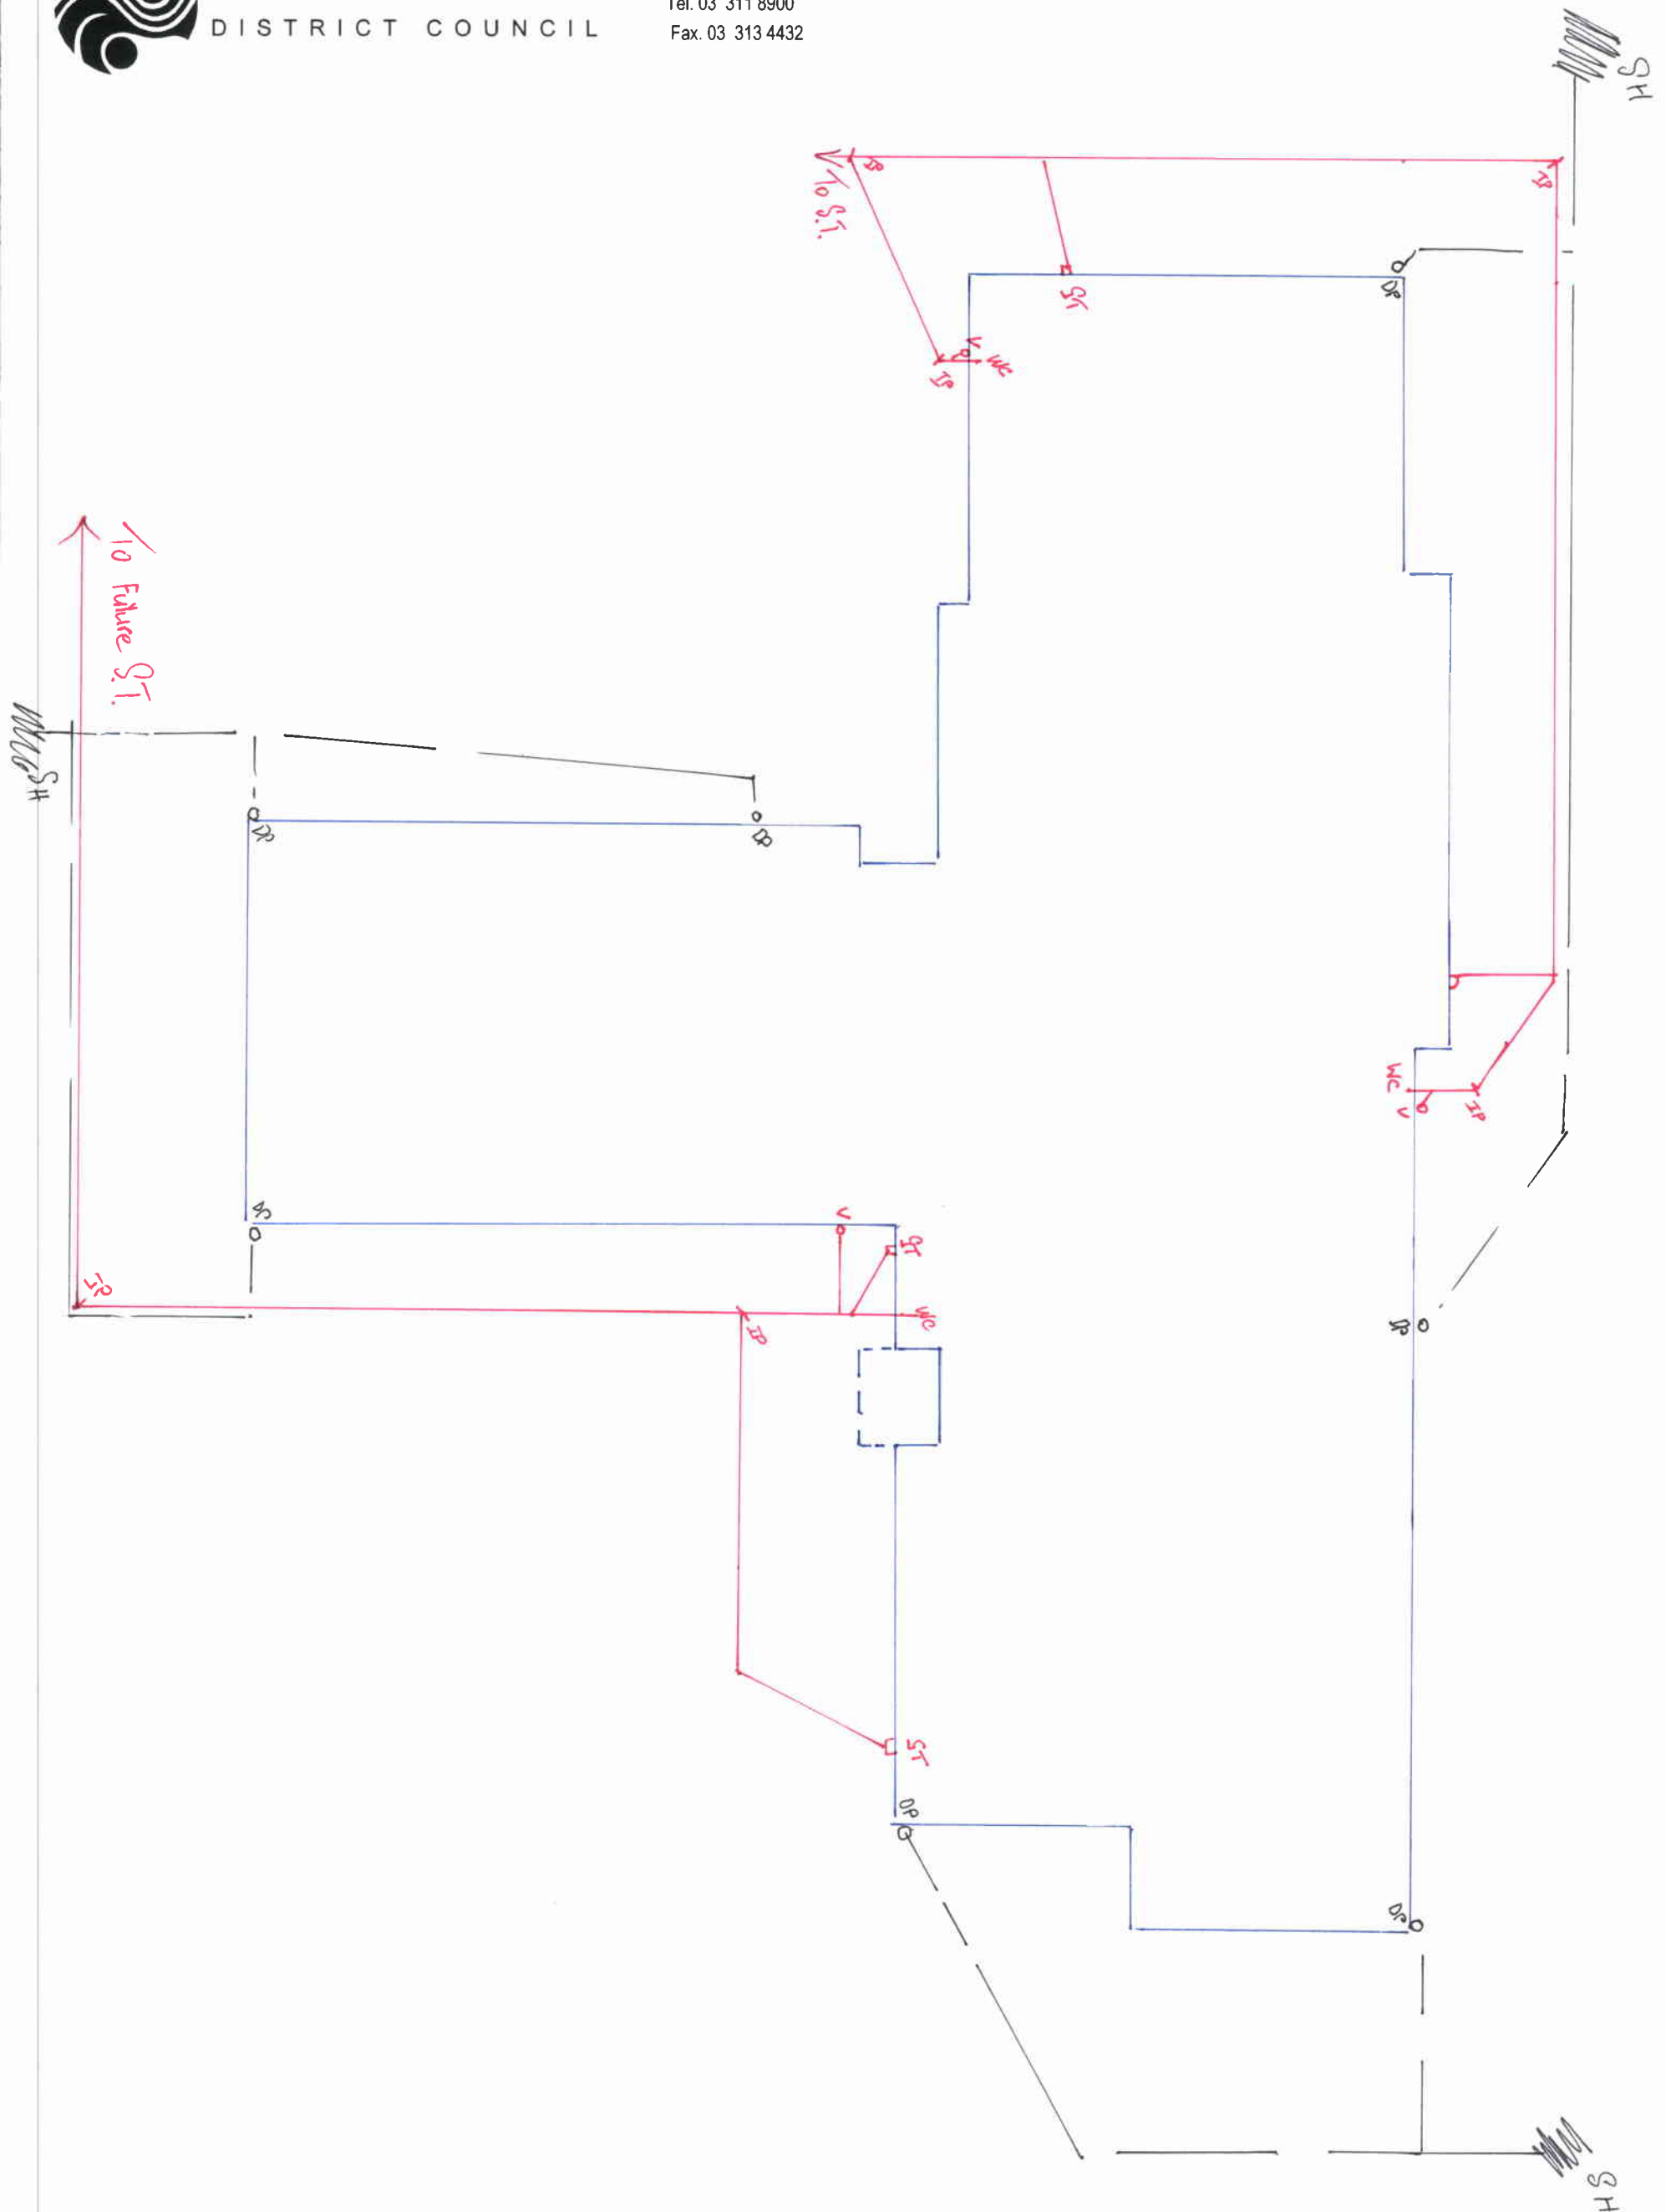

LEGEND: SEWER — STORMWATER —		DRAINAGE PLAN	
SCALE: 1-100	DRAWN BY: Les Crosswell	JOB N°: 122095	VAL N°: 2175068109
NAME: D McNicholl		INSPECTED: L.B.	
ADDRESS: 55 Mandeville Park Mandeville North		DATE DRAWN: 9-7-13	
DRAINLAYER: McKay-Moore			